


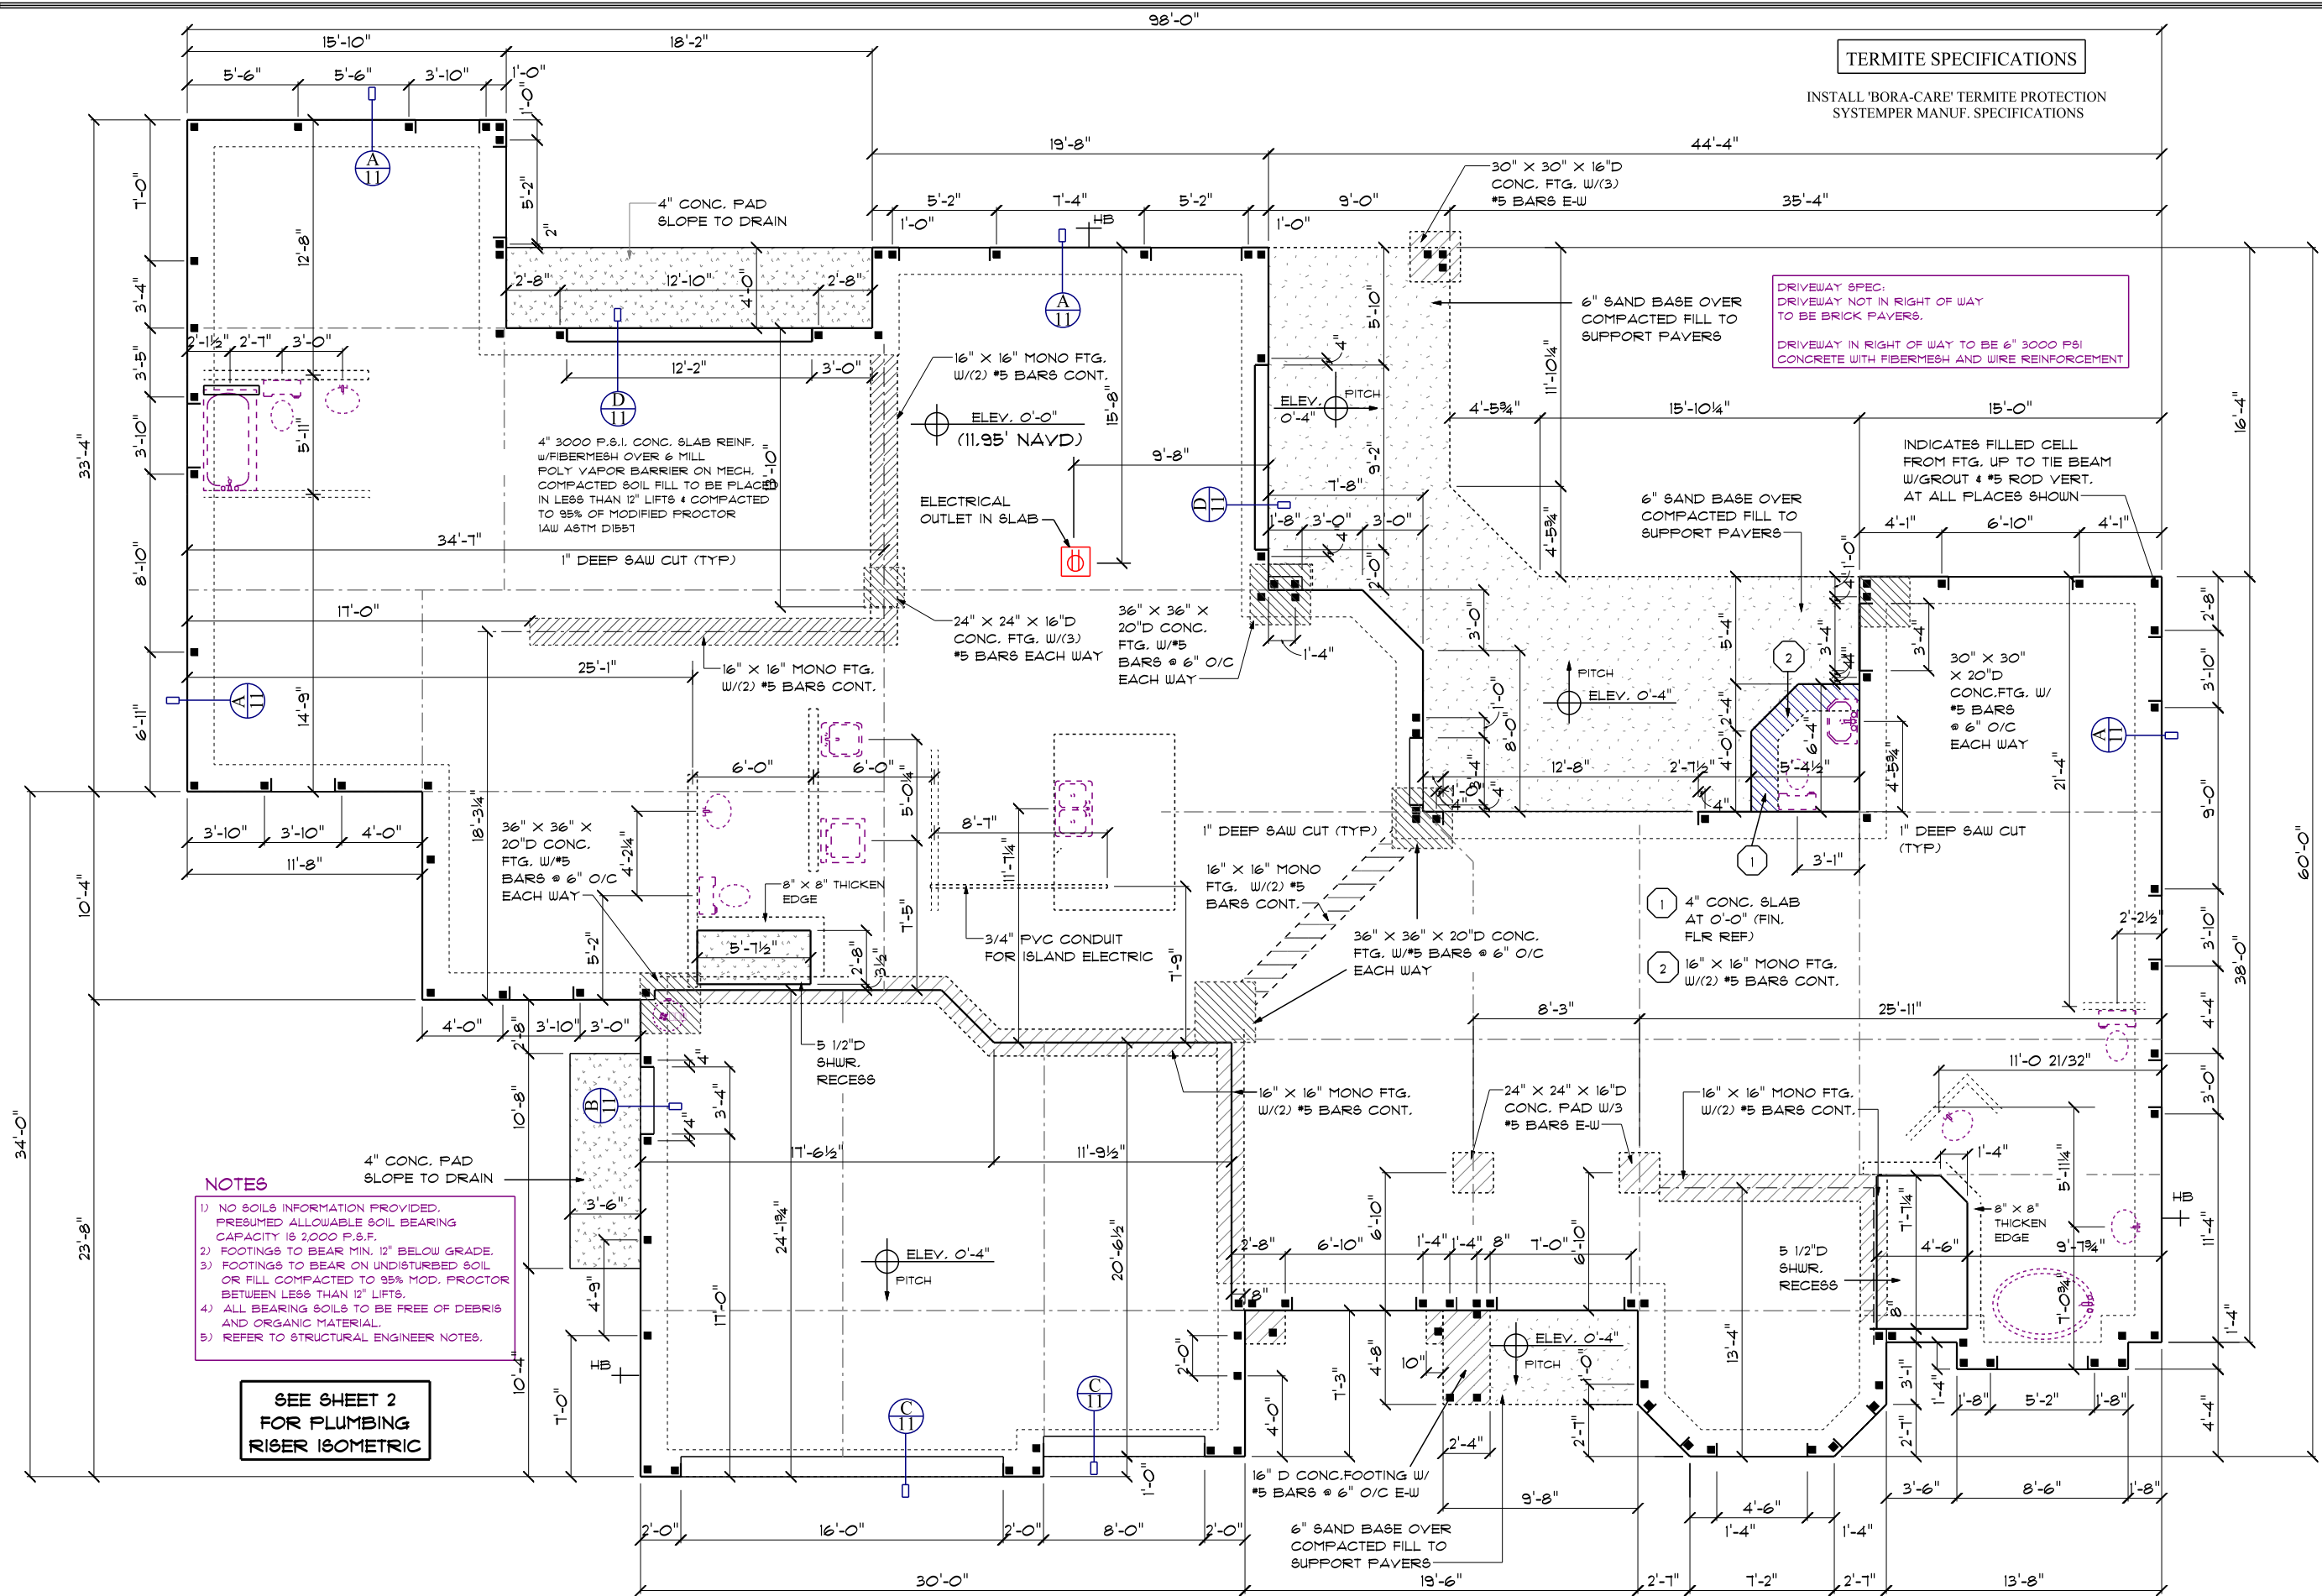

- NOTES**
- 1) NO SOILS INFORMATION PROVIDED. PRESUMED ALLOWABLE SOIL BEARING CAPACITY IS 2,000 P.S.F.
 - 2) FOOTINGS TO BEAR MIN. 12" BELOW GRADE.
 - 3) FOOTINGS TO BEAR ON UNDISTURBED SOIL OR FILL COMPACTED TO 95% MOD. PROCTOR BETWEEN LESS THAN 12" LIFTS.
 - 4) ALL BEARING SOILS TO BE FREE OF DEBRIS AND ORGANIC MATERIAL.
 - 5) REFER TO STRUCTURAL ENGINEER NOTES.

SEE SHEET 2
FOR PLUMBING
RISER ISOMETRIC

TERMITE SPECIFICATIONS

INSTALL 'BORA-CARE' TERMITE PROTECTION
SYSTEM PER MANUF. SPECIFICATIONS

DRIVEWAY SPEC:
DRIVEWAY NOT IN RIGHT OF WAY
TO BE BRICK PAVERS.

DRIVEWAY IN RIGHT OF WAY TO BE 6" 3000 PSI
CONCRETE WITH FIBERMESH AND WIRE REINFORCEMENT

INDICATES FILLED CELL
FROM FTG. UP TO THE BEAM
W/ GROUT & #5 ROD VERT.
AT ALL PLACES SHOWN

**ALLEN ENGINEERING &
CONSTRUCTION SERVICES**
RICH ALLEN PROFESSIONAL ENGINEER
P.E. #56920 C.A. #9542
P.O. BOX 351
NEW PORT RICHEY, FL 34656
727-842-6100
richallenpe@gmail.com

I HEREBY CERTIFY THAT I HAVE
PREPARED THE ABOVE DESIGN
TO COMPLY WITH ALL APPLICABLE
WIND LOADS, EXPOSURE B AND IT IS
IN COMPLIANCE WITH CHAPTER 16 OF
THE 2010 FLORIDA BUILDING CODE.
SEALED FOR THE STRUCTURE ONLY.
SIGNED
RICHARD E. ALLEN P.E. #56920

**LOT 9
PLANTATION**

PLAN DATE	
1. 04-02-2015	5. 09-18-2015
2. 04-07-2015	
3. 04-10-2015	
4. 04-15-2015	
5. 09-14-2015	


**DEEB FAMILY
HOMES, LTD.**
9400 RIVER CROSSING BLD.
NEW PORT RICHEY, FL. 34655

1

A.E.C.S # 15031 LAUREL 3428

SCALE 1/8" = 1'-0"

FOUNDATION PLAN

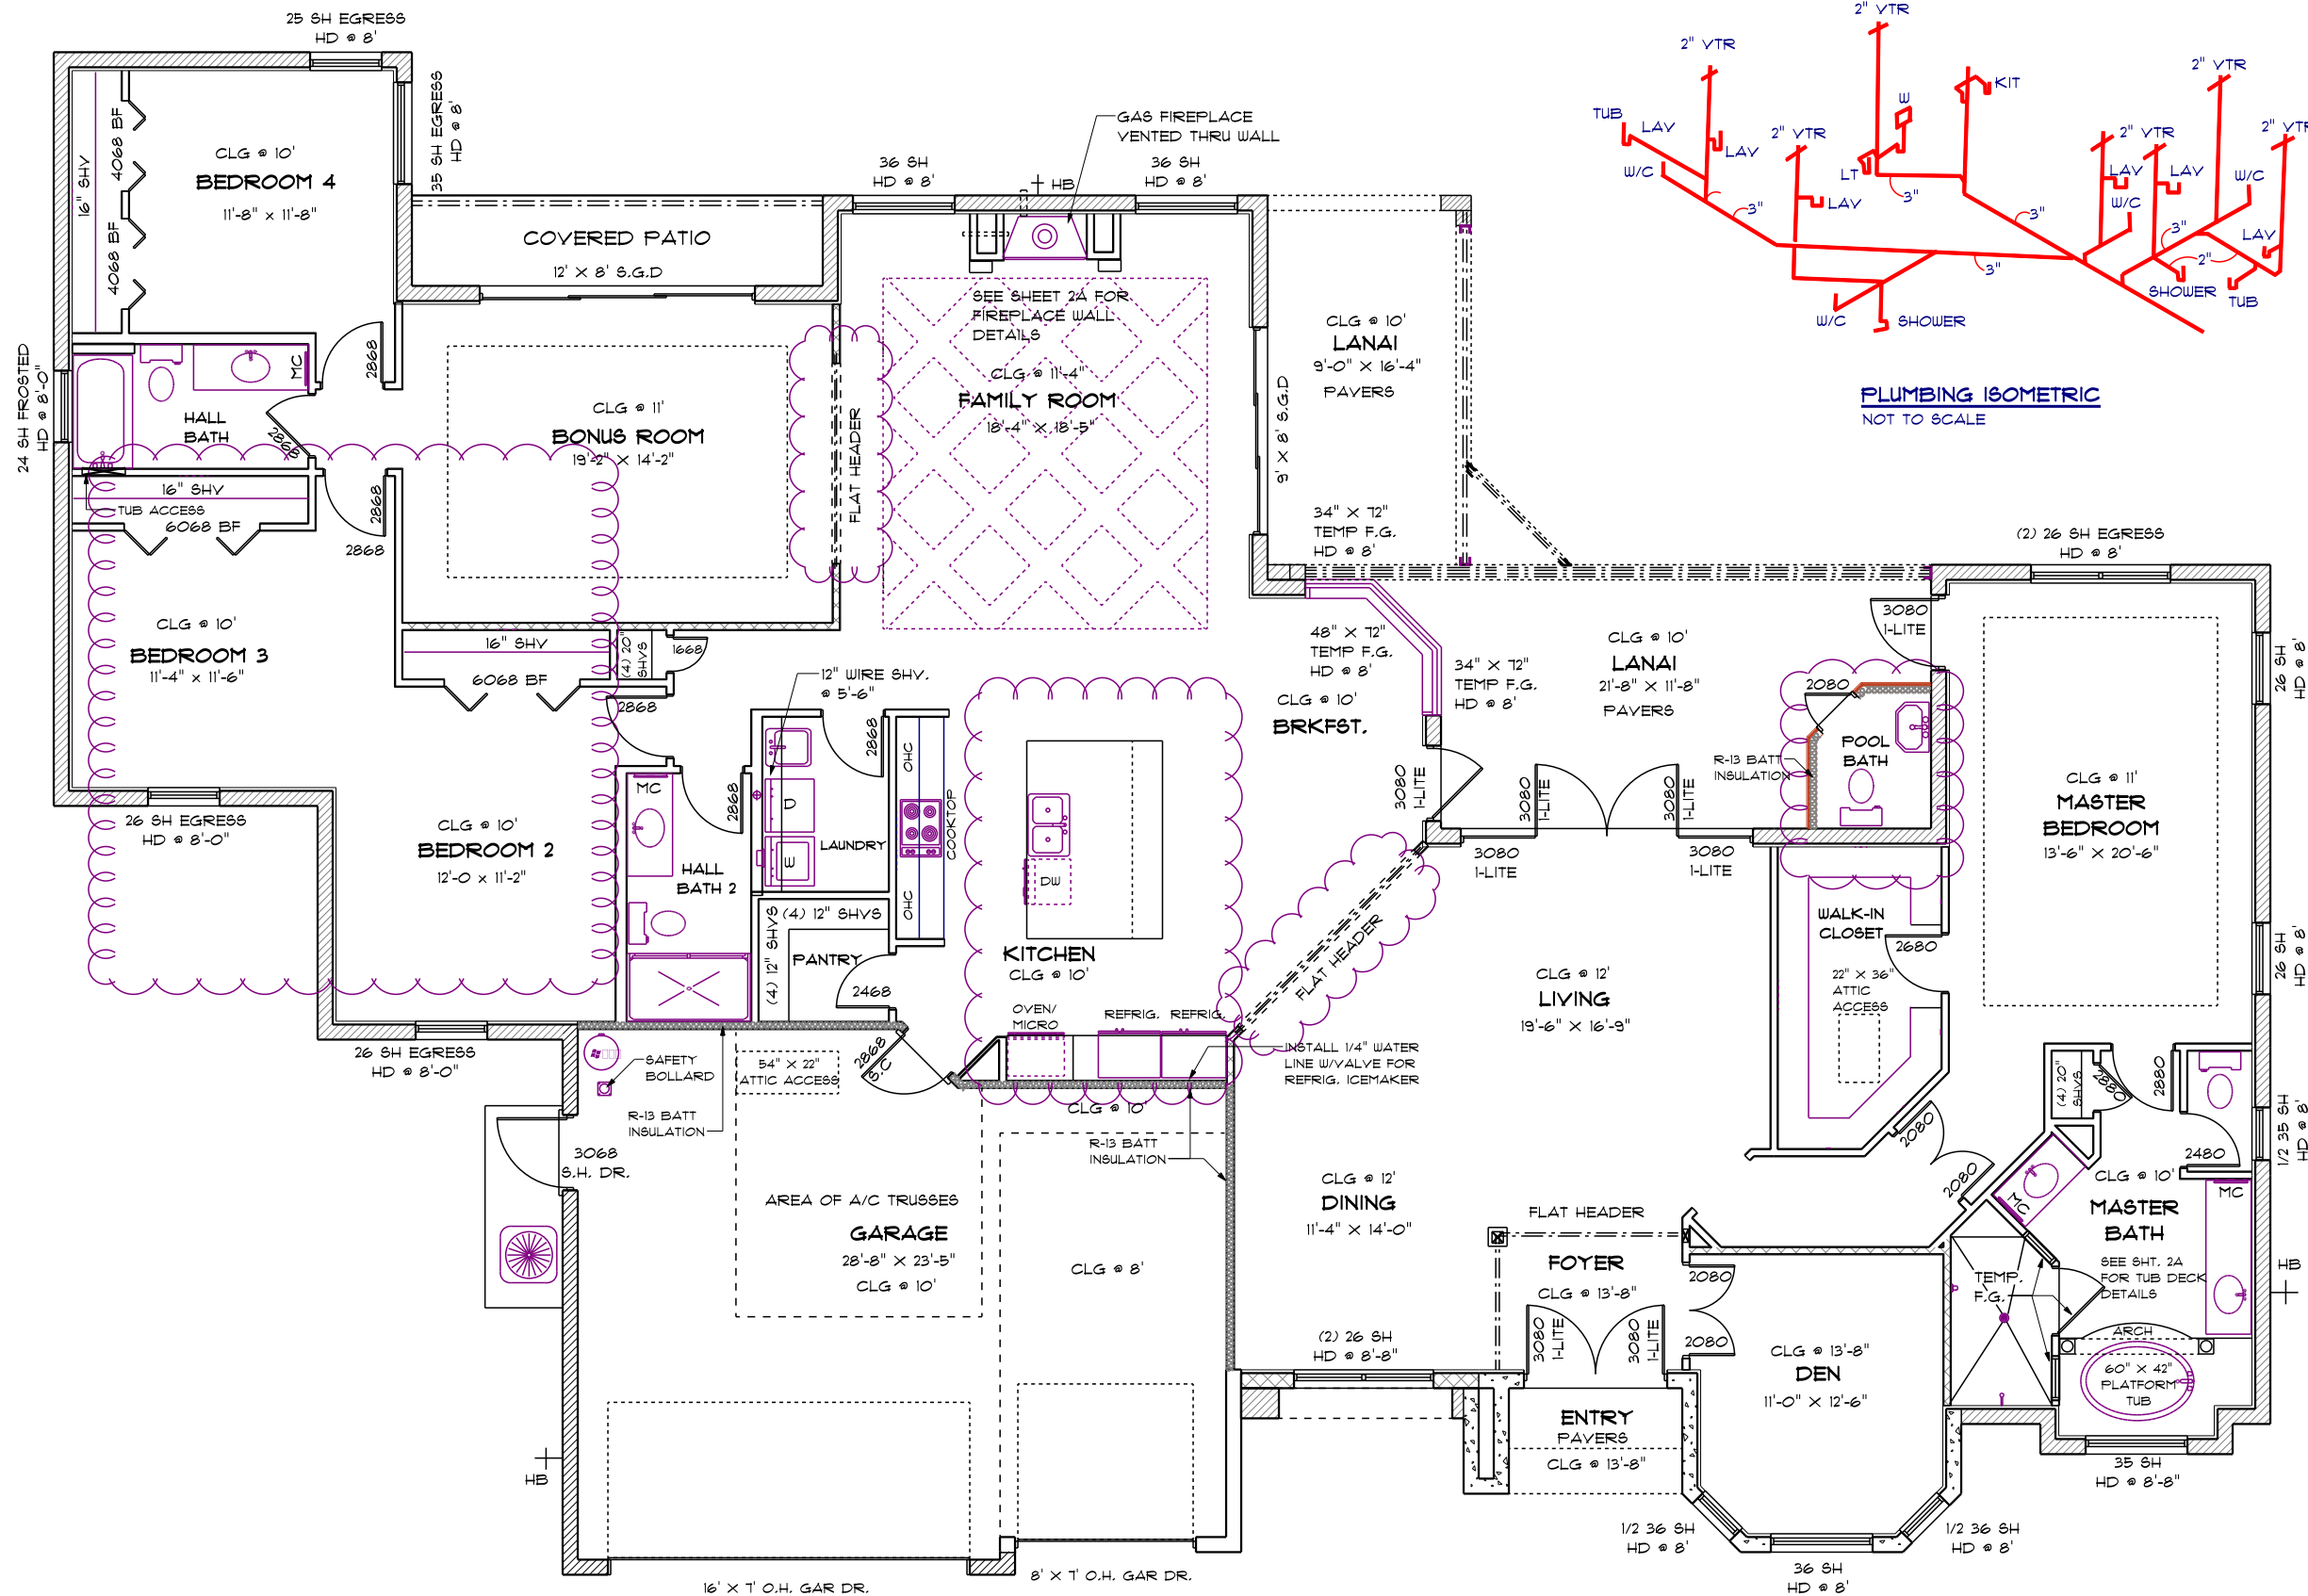

FLOOR PLAN NOTES

SCALE 1/8" = 1'-0"

LAUREL 3428

DEEB FAMILY
HOMES, LTD.
9400 RIVER CROSSING BLD.
NEW PORT RICHEY, FL. 34655


PLAN DATE

1.	04-02-2015	6.09-01-2015
2.	04-07-2015	7.09-10-2015
3.	04-10-2015	8.09-14-2015
4.	04-15-2015	9.09-18-2015
5.	04-17-2015	


LOT 9
PLANTATION




ROBBIAN DESIGN
AL ROBBIAN A.I.B.D
6397 CONNIEWOOD SQ.
NEW PORT RICHEY, FL. 34653
(727) 848-2259
MAIL - al@robbiandesign.com

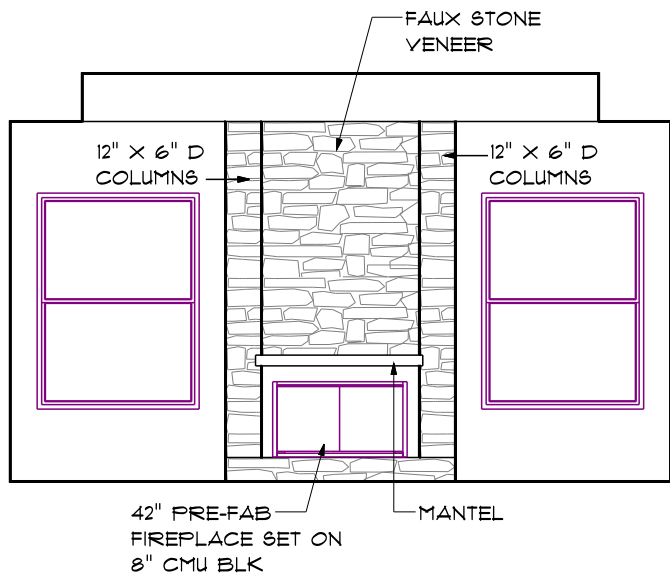


FAMILY ROOM FIREPLACE WALL

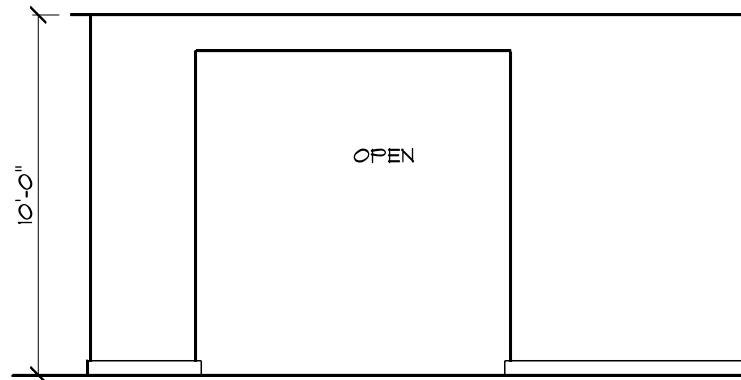


BONUS WALL OPENING

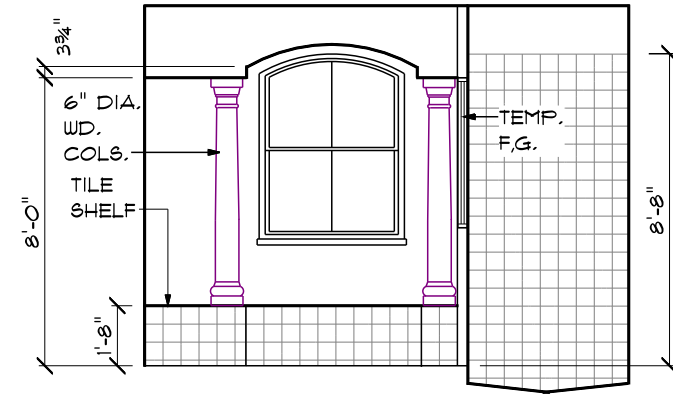


MASTER BATH TUB WALL

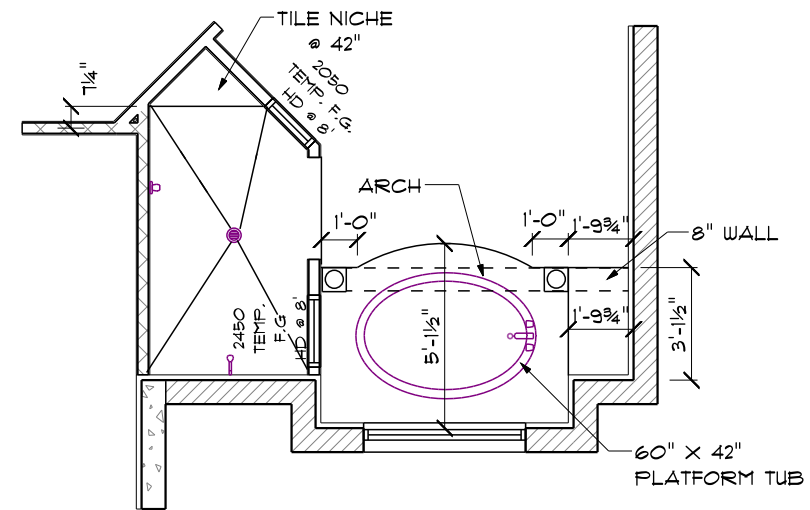

MASTER BATH TUB DECK

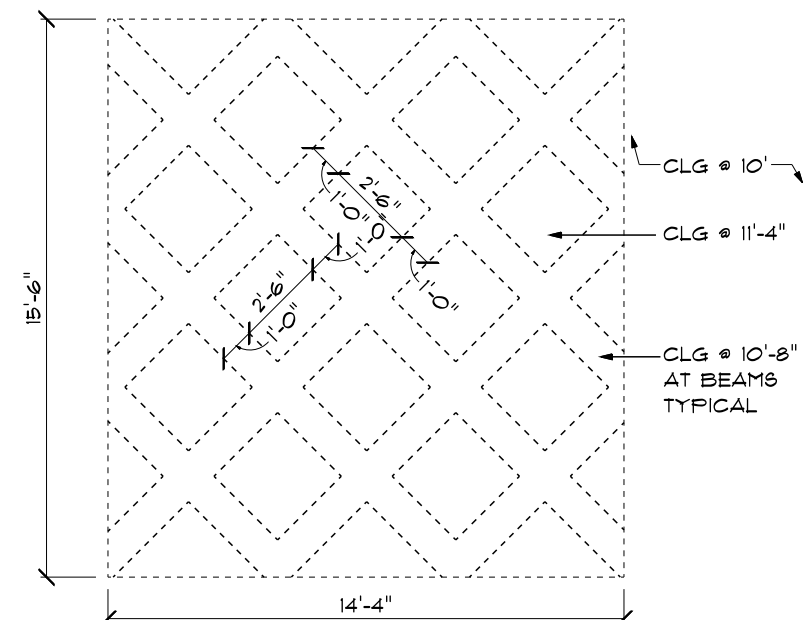

FAMILY ROOM BEAM CLG. LAYOUT

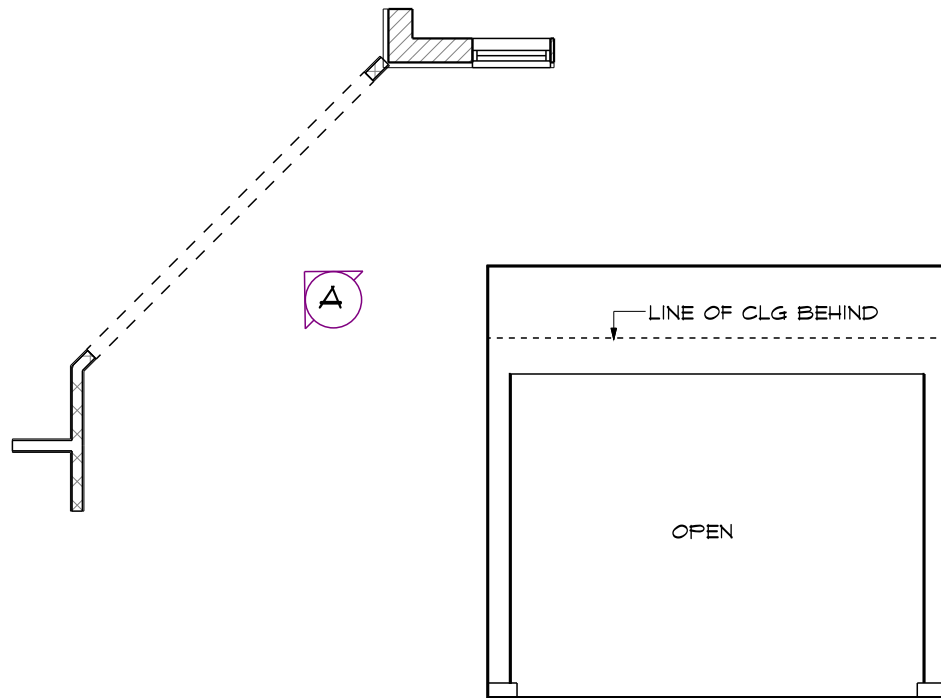

A LIVING ROOM WALL OPENING

FLOOR PLAN DETAILS

SCALE 3/16" = 1'-0"


LAUREL 3428

DEEB FAMILY
HOMES, LTD.
9400 RIVER CROSSING BLD.
NEW PORT RICHEY, FL. 34655


LOT 9
PLANTATION

PLAN DATE	1. 04-02-2015	2. 04-07-2015	3. 04-10-2015	4. 04-15-2015	5. 04-17-2015
	6. 09-01-2015	7. 09-10-2015	8. 09-14-2015	9. 09-18-2015	

 ROBBIAN DESIGN
AL ROBBIAN A.I.B.D
6397 CONNIEWOOD SQ.
NEW PORT RICHEY, FL. 34653
(727) 848-2259
MAIL - al@robbiandesign.com



2A

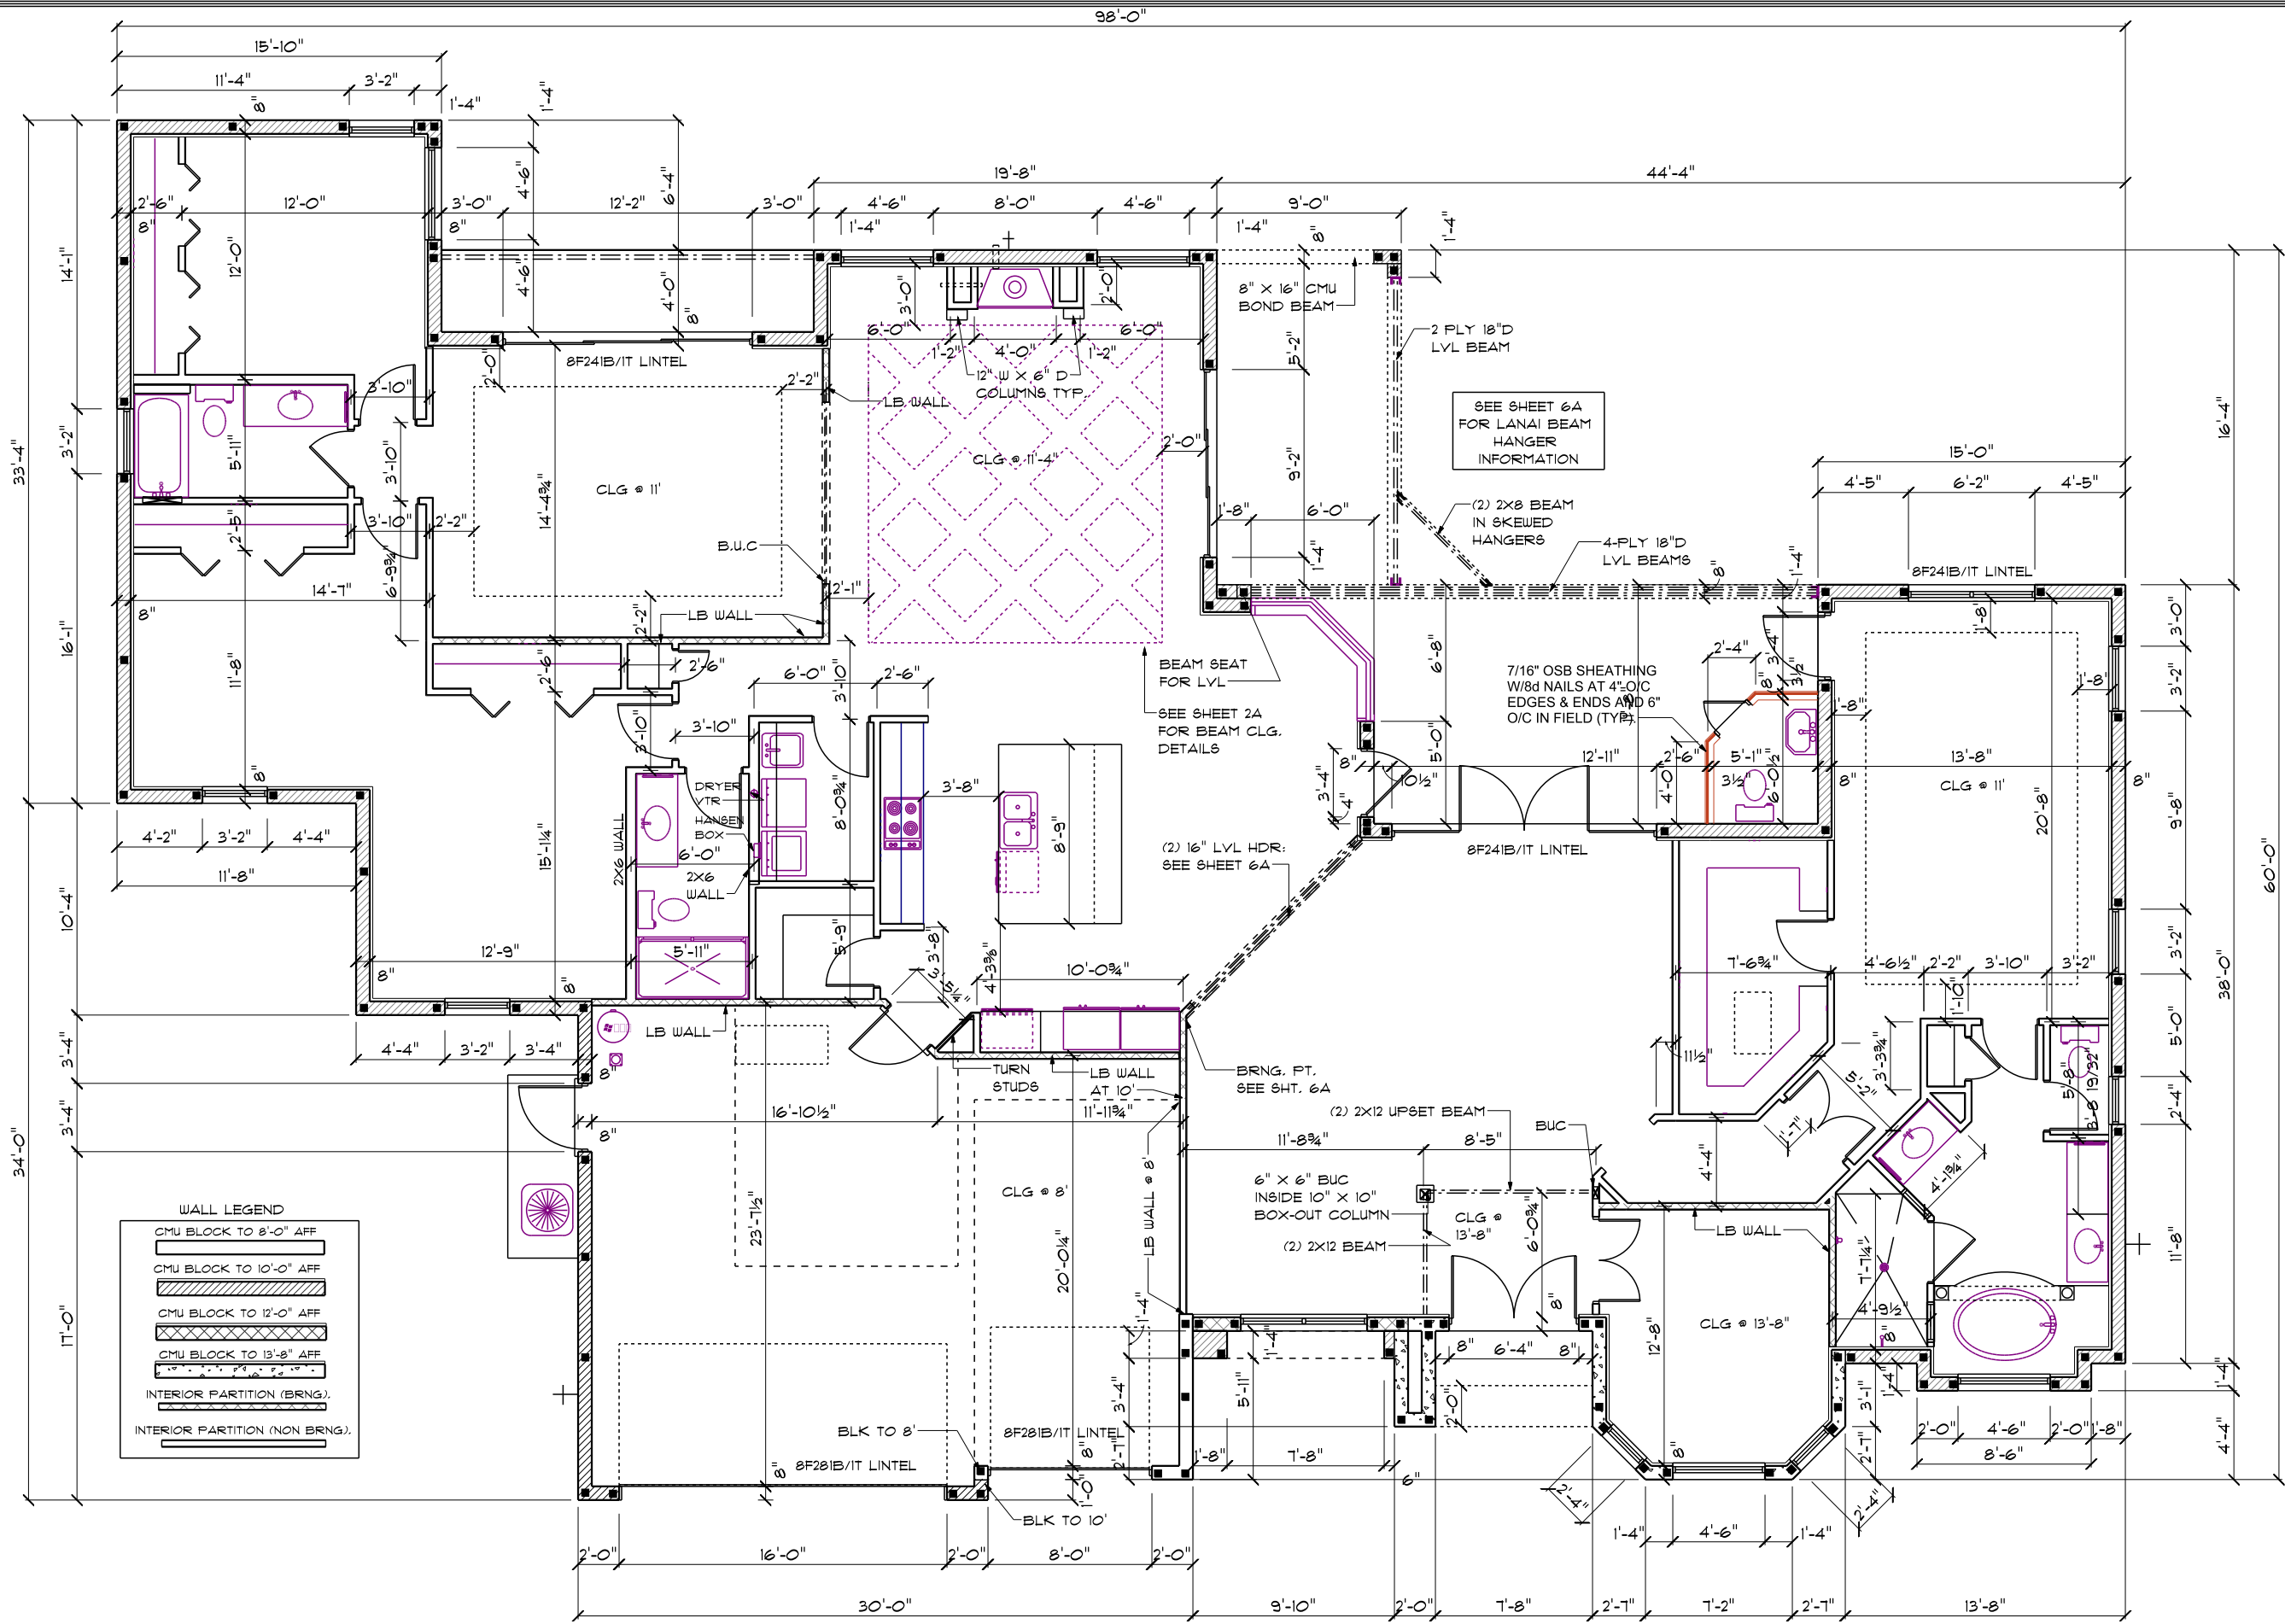

DIMENSION PLAN


SCALE 1/8" = 1'-0"

A.E.C.S # 15031 LAUREL 3428


PLAN DATE	
1. 04-02-2015	5. 09-18-2015
2. 04-07-2015	
3. 04-10-2015	
4. 04-15-2015	
5. 09-14-2015	

I HEREBY CERTIFY THAT I HAVE
DESIGNED THE ABOVE PROJECT
TO COMPLY WITH ALL APPLICABLE
WIND LOADS, EXPOSURE B AND IT IS
IN COMPLIANCE WITH CHAPTER 16 OF
THE 2010 FLORIDA BUILDING CODE.
SEALED FOR THE STRUCTURE ONLY.

ALLEN ENGINEERING &
CONSTRUCTION SERVICES
RICH ALLEN PROFESSIONAL ENGINEER
P.E. #56920 C.A. #9542
P.O. BOX 351
NEW PORT RICHEY, FL 34656
727-842-6100
richallenpe@gmail.com

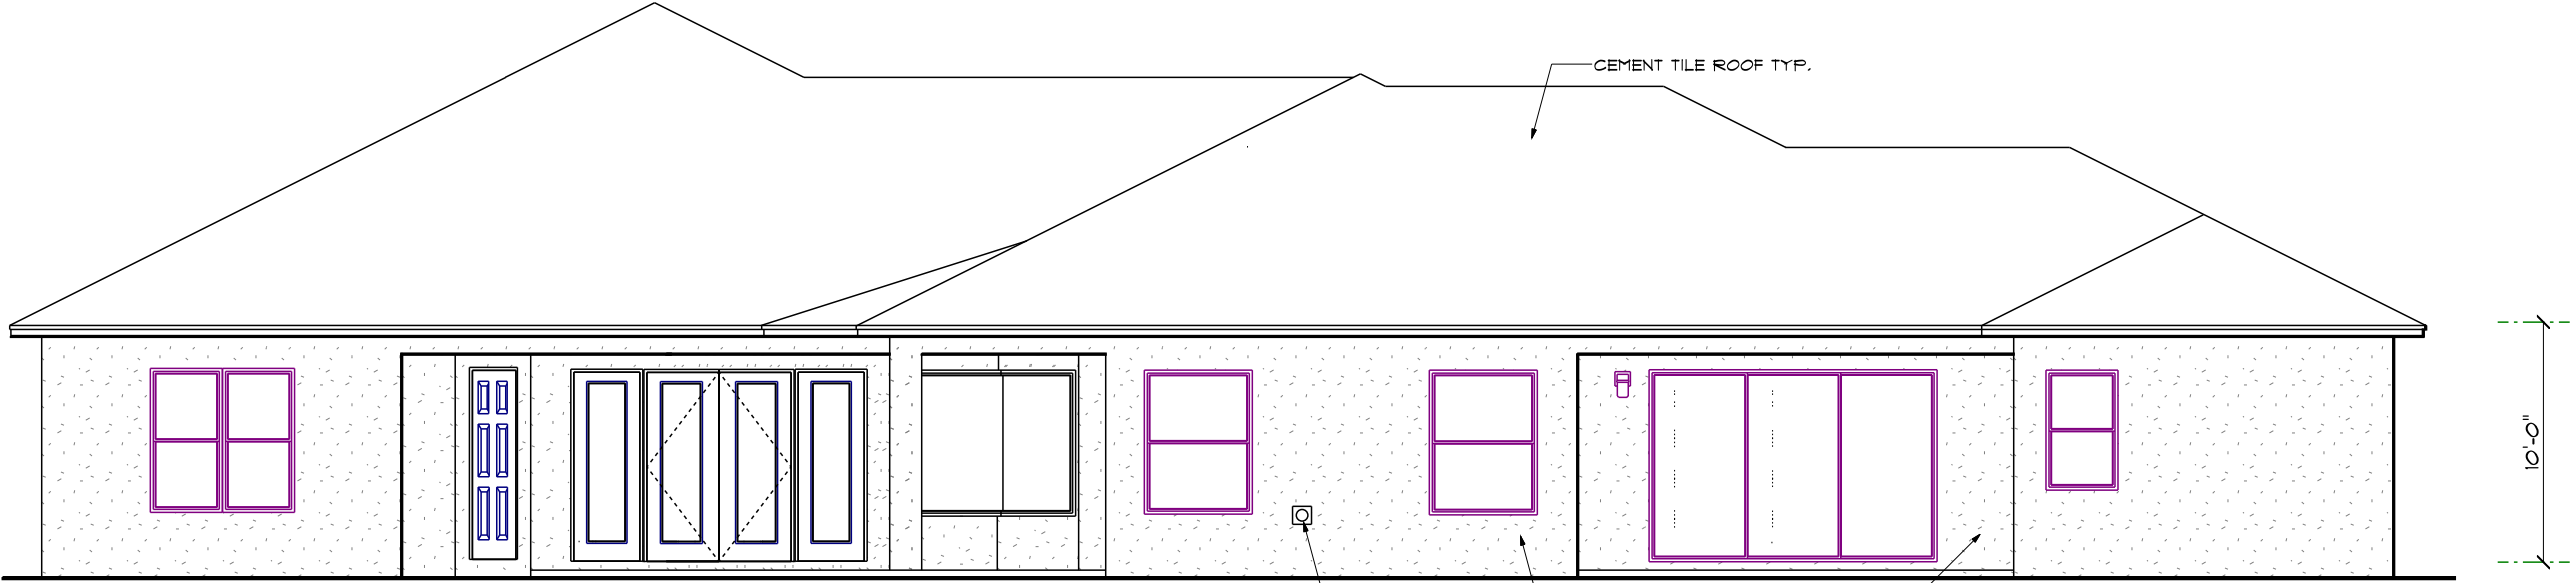


REAR ELEVATION

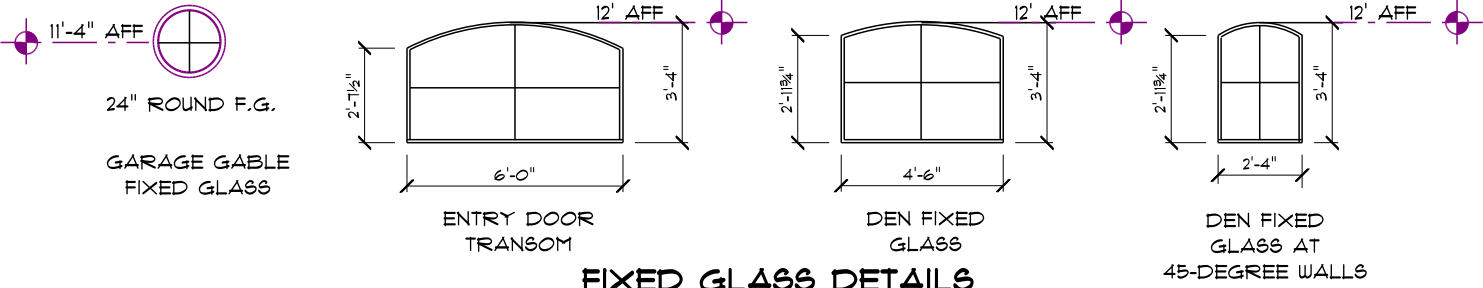

FIXED GLASS DETAILS

3/16" = 1'-0"

1/8" STUCCO FINISH PER ASTM C-926-11a ON PAPER BACKED METAL LATH OVER TYVEK (OR EQUIVALENT). VINYL VAPOR BARRIER ON EXTERIOR WOOD SHEATHING.

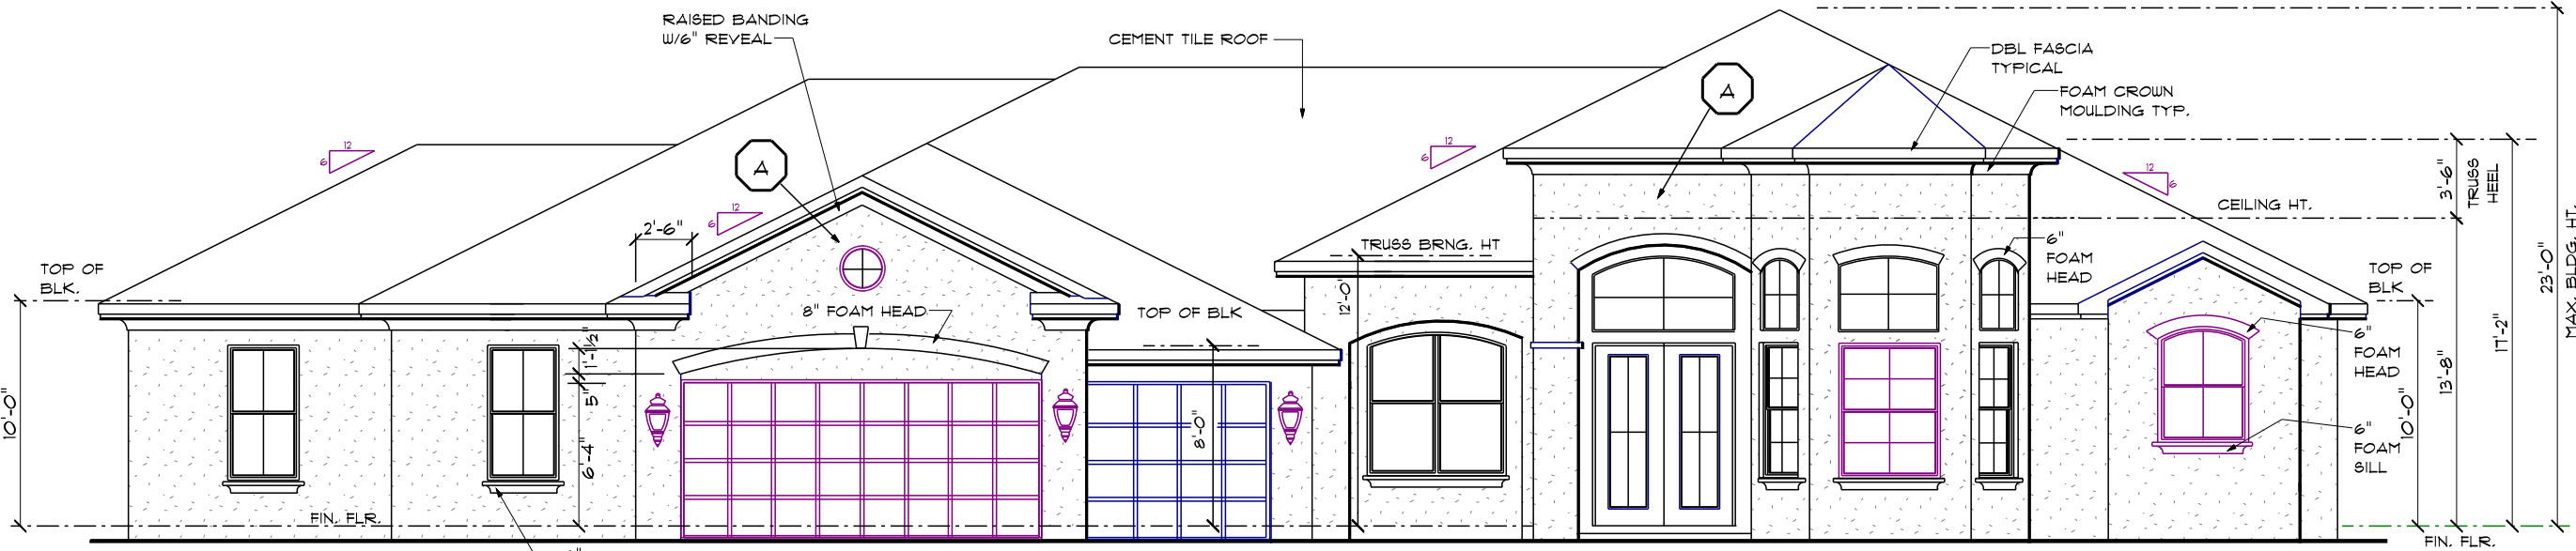

FRONT ELEVATION

EXTERIOR ELEVATIONS

SCALE 1/8" = 1'-0"

LAUREL 3428

DEEB FAMILY
HOMES, LTD.
9400 RIVER CROSSING BLD.
NEW PORT RICHEY, FL. 34655


LOT 9
PLANTATION

PLAN DATE				
1. 04-02-2015	6. 09-01-2015	7. 09-10-2015	8. 09-14-2015	
2. 04-07-2015				
3. 04-10-2015				
4. 04-15-2015				
5. 04-17-2015				


4

ROBBIAN DESIGN
AL ROBBIAN A.I.B.D
6397 CONNIEWOOD SQ.
NEW PORT RICHEY, FL. 34653
(727) 848-2259
MAIL - al@robbiandesign.com




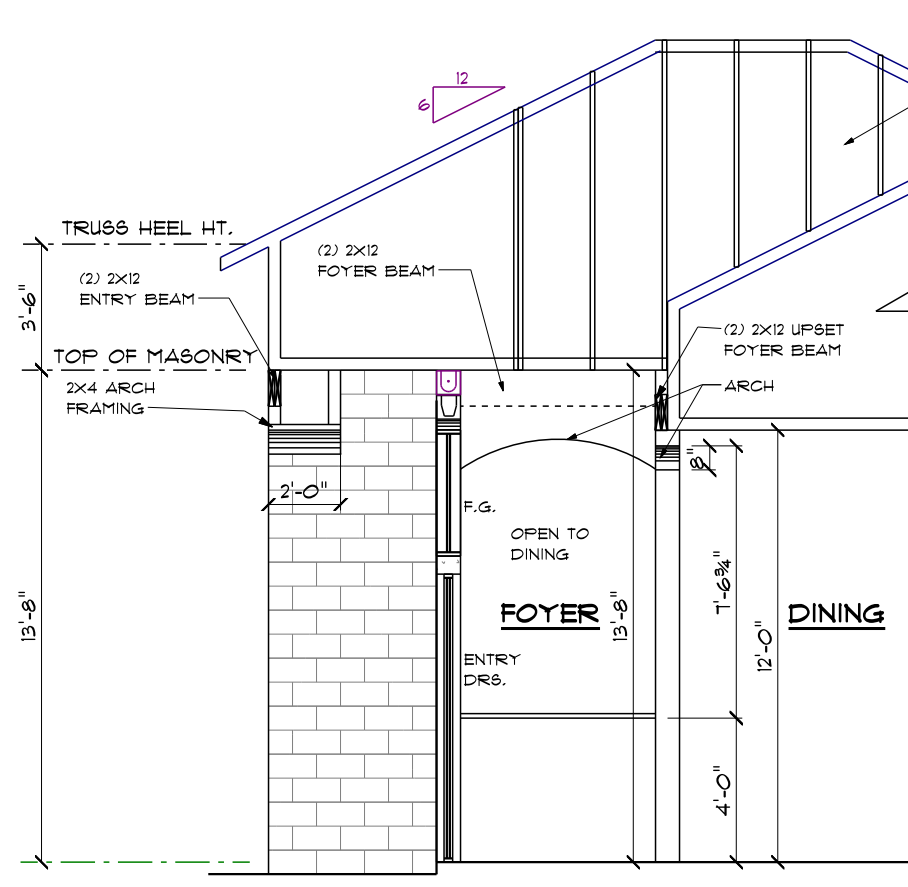


ENTRY SECTION A

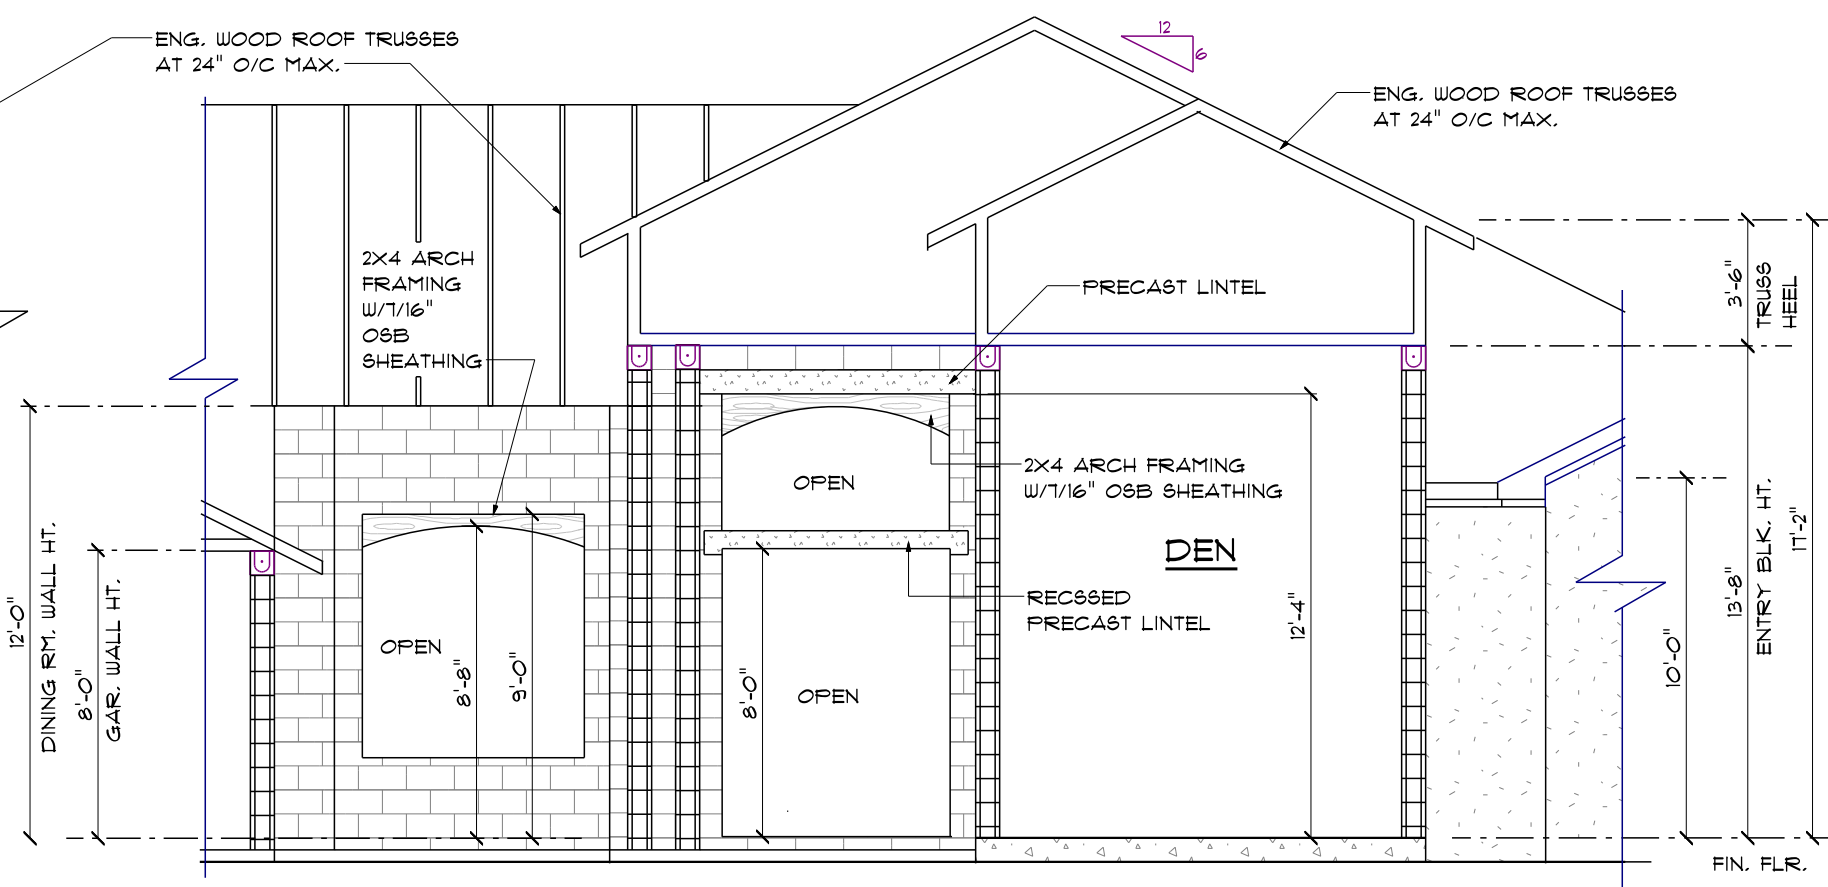

ENTRY SECTION B

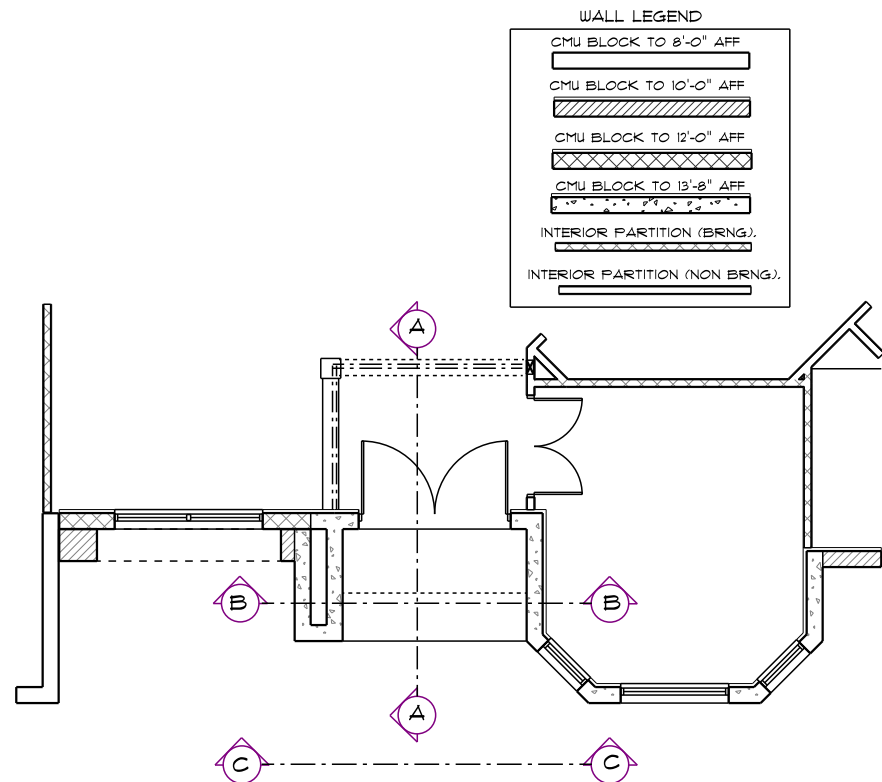

ENTRY PLAN

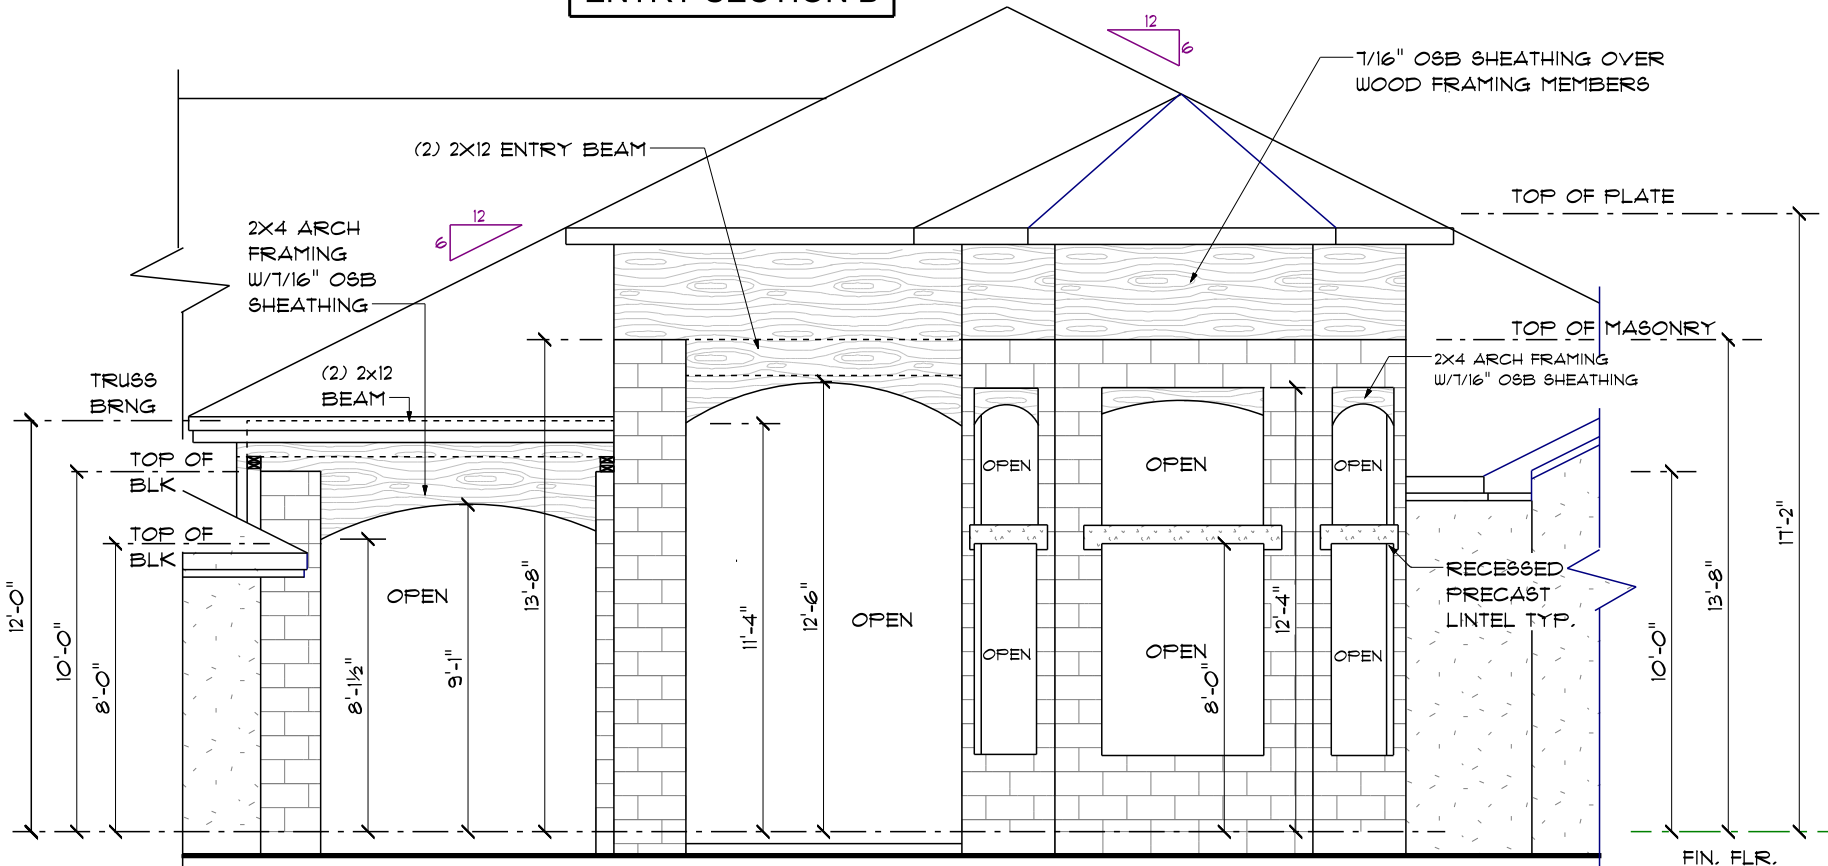

ENTRY CONSTRUCTION ELEVATION C

ENTRY CONSTRUCTION DETAILS

SCALE 3/16" = 1'-0"

A.E.C.S # 15031 LAUREL 3428

4A

DEEB FAMILY HOMES, LTD.
9400 RIVER CROSSING BLD.
NEW PORT RICHEY, FL. 34655


PLAN DATE	
1. 04-02-2015	
2. 04-07-2015	
3. 04-10-2015	
4. 04-15-2015	
4. 09-14-2015	

LOT 9
PLANTATION


I HEREBY CERTIFY THAT I HAVE PERFORMED THE ATTACHED DESIGN TO COMPLY WITH 145 MPH ULTIMATE WIND LOADS, EXPOSURE B AND IT IS IN COMPLIANCE WITH CHAPTER 16 OF THE 2010 FLORIDA BUILDING CODE. SEALED FOR THE STRUCTURE ONLY.
SIGNED: RICHARD E. ALLEN P.E. #56920

ALLEN ENGINEERING & CONSTRUCTION SERVICES
RICH ALLEN PROFESSIONAL ENGINEER
P.E. #56920 C.A. #542
P.O. BOX 351
NEW PORT RICHEY, FL 34656
727-842-6100
richallenpe@gmail.com

A 1/8" STUCCO FINISH PER ASTM C-926-11a
ON PAPER BACKED METAL LATH OVER TYVEK
(OR EQUIVALENT). VINYL VAPOR BARRIER ON
EXTERIOR WOOD SHEATHING.

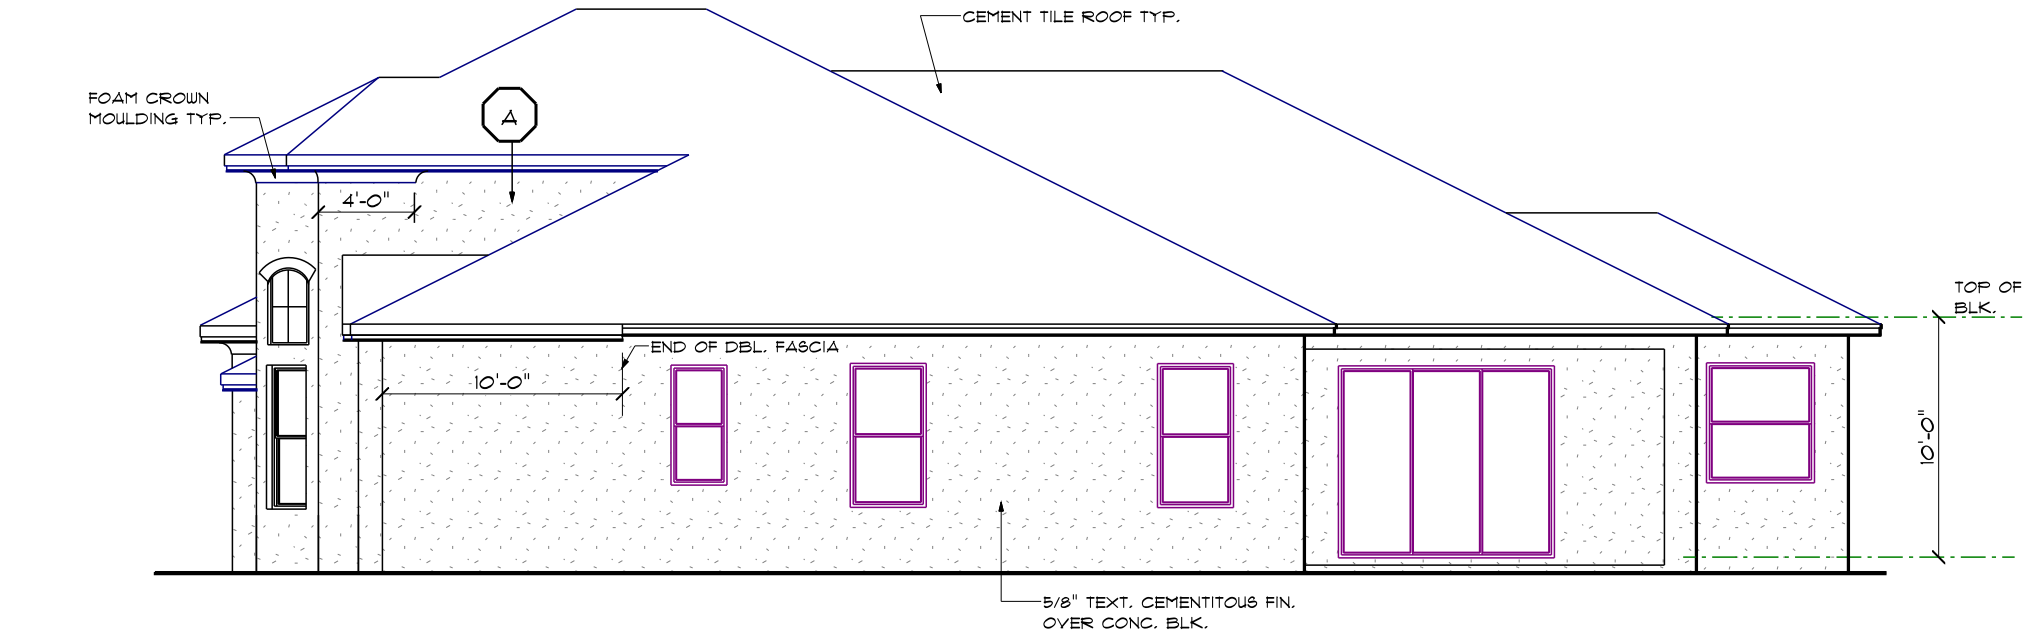

RIGHT ELEVATION

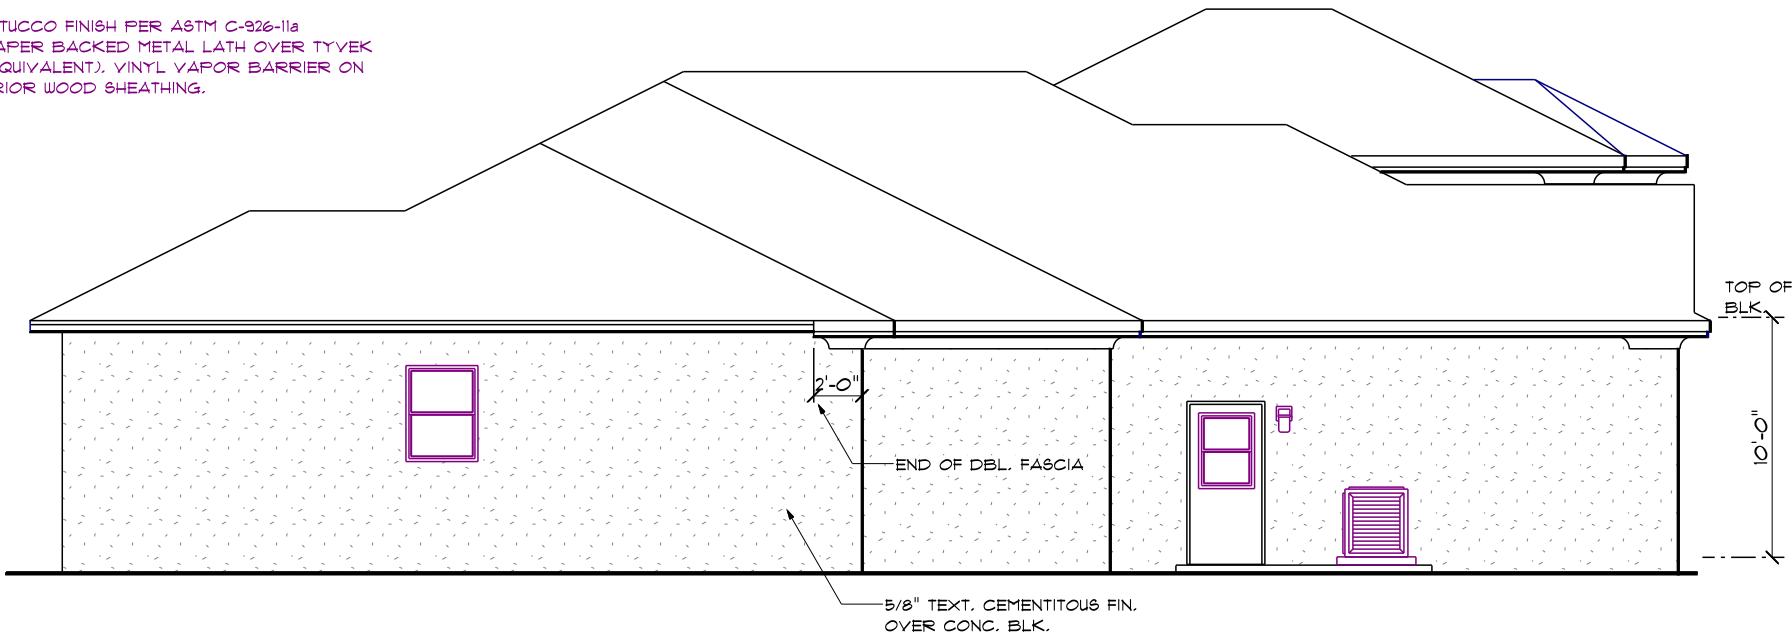

LEFT ELEVATION

EXTERIOR ELEVATIONS

SCALE 1/8" = 1'-0"

LAUREL 3428

DEEB FAMILY
HOMES, LTD.
9400 RIVER CROSSING BLD.
NEW PORT RICHEY, FL. 34655


PLAN DATE									
1. 04-02-2015	6. 09-01-2015	7. 09-10-2015	8. 09-14-2015						
2. 04-07-2015	7. 09-10-2015	8. 09-14-2015							
3. 04-10-2015	8. 09-14-2015								
4. 04-15-2015									
5. 04-17-2015									

LOT 9
PLANTATION



ROBBIAN DESIGN
AL ROBBIAN A.I.B.D
6397 CONNIEWOOD SQ.
NEW PORT RICHEY, FL. 34653
(727) 848-2259
MAIL - al@robbiandesign.com

5

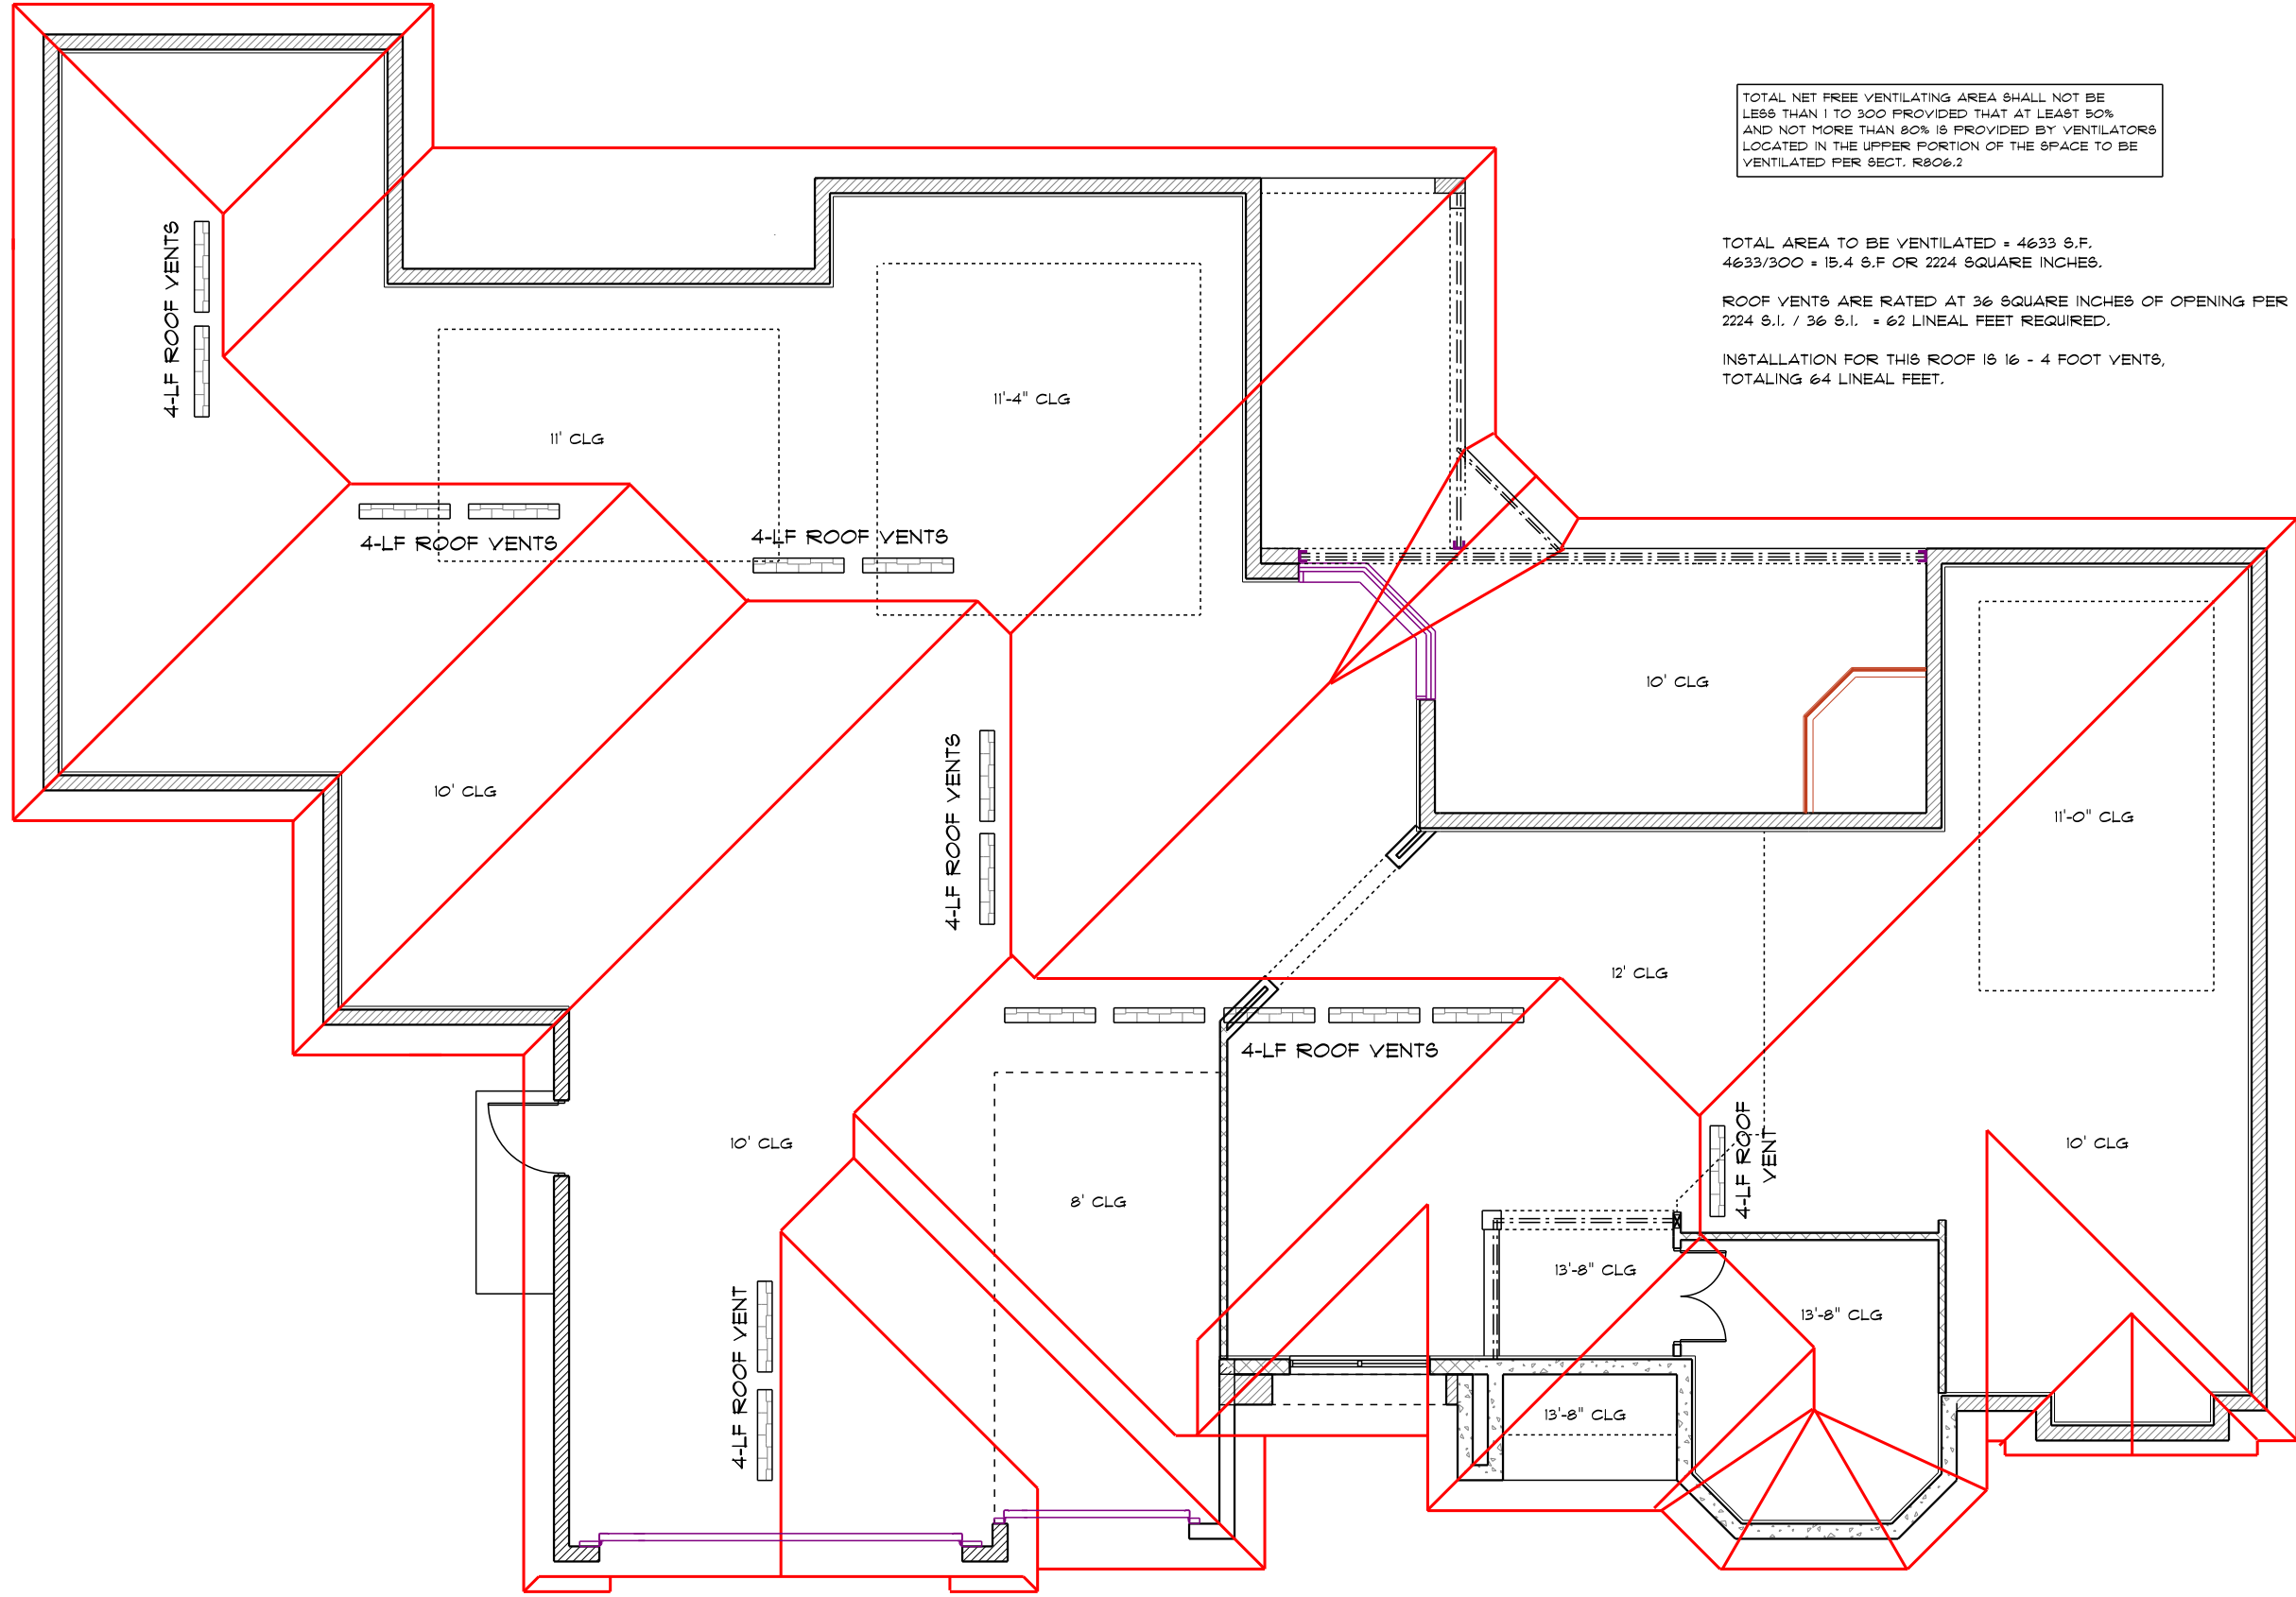

TOTAL NET FREE VENTILATING AREA SHALL NOT BE LESS THAN 1 TO 300 PROVIDED THAT AT LEAST 50% AND NOT MORE THAN 80% IS PROVIDED BY VENTILATORS LOCATED IN THE UPPER PORTION OF THE SPACE TO BE VENTILATED PER SECT. R206.2

TOTAL AREA TO BE VENTILATED = 4633 S.F.
4633/300 = 15.4 S.F OR 2224 SQUARE INCHES.

ROOF VENTS ARE RATED AT 36 SQUARE INCHES OF OPENING PER LINEAL FT.
2224 S.I. / 36 S.I. = 62 LINEAL FEET REQUIRED.

INSTALLATION FOR THIS ROOF IS 16 - 4 FOOT VENTS,
TOTALING 64 LINEAL FEET.

ROOF PLAN

SCALE 1/8" = 1'-0"

LAUREL 3428

DEEB FAMILY
HOMES, LTD.
9400 RIVER CROSSING BLD.
NEW PORT RICHEY, FL. 34655


PLAN DATE	
1. 04-02-2015	6. 09-01-2015
2. 04-07-2015	7. 09-10-2015
3. 04-10-2015	8. 09-14-2015
4. 04-15-2015	
5. 04-17-2015	

LOT 9
PLANTATION



ROBBIAN DESIGN
AL ROBBIAN A.I.B.D
6397 CONNIEWOOD SQ.
NEW PORT RICHEY, FL. 34653
(727) 848-2259
MAIL - al@robbiandesign.com

6

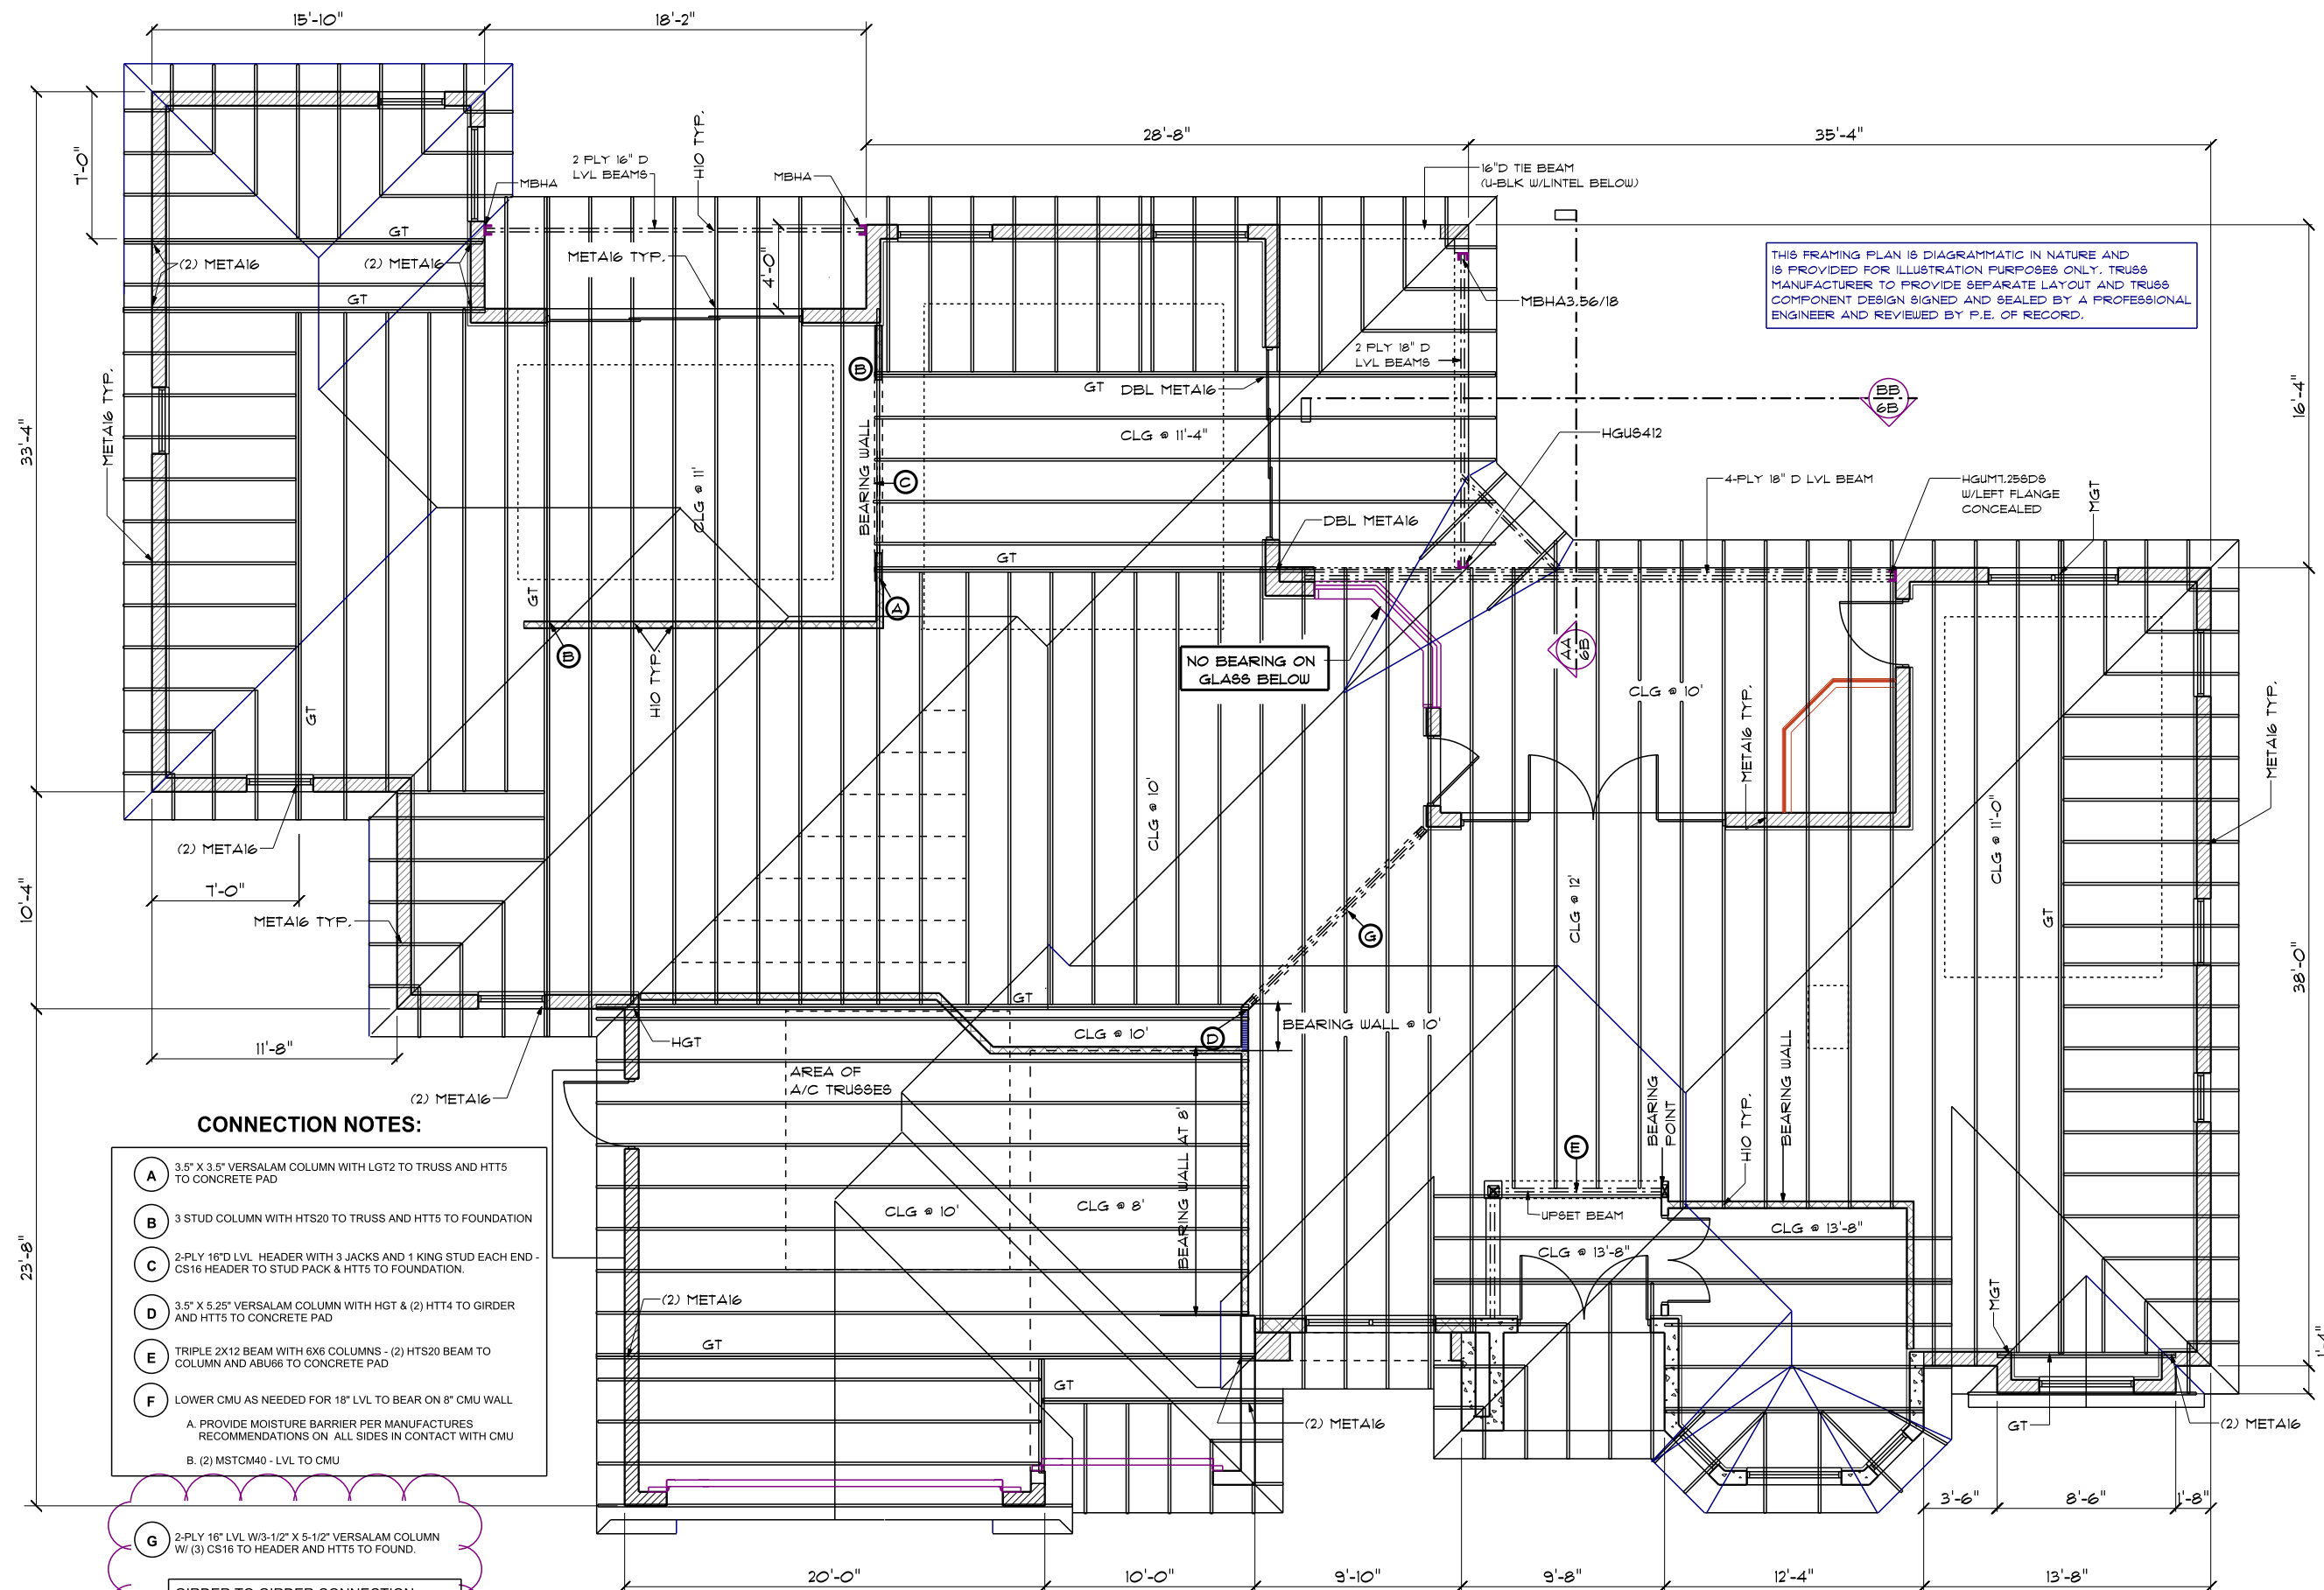

CONNECTION NOTES:

- A** 3.5" X 3.5" VERSALAM COLUMN WITH LGT2 TO TRUSS AND HTT5 TO CONCRETE PAD
- B** 3 STUD COLUMN WITH HTS20 TO TRUSS AND HTT5 TO FOUNDATION
- C** 2-PLY 16"D LVL HEADER WITH 3 JACKS AND 1 KING STUD EACH END CS16 HEADER TO STUD PACK & HTT5 TO FOUNDATION.
- D** 3.5" X 5.25" VERSALAM COLUMN WITH HGT & (2) HTT4 TO GIRDER AND HTT5 TO CONCRETE PAD
- E** TRIPLE 2X12 BEAM WITH 6X6 COLUMNS - (2) HTS20 BEAM TO COLUMN AND ABU66 TO CONCRETE PAD
- F** LOWER CMU AS NEEDED FOR 18" LVL TO BEAR ON 8" CMU WALL
 - A.** PROVIDE MOISTURE BARRIER PER MANUFACTURES RECOMMENDATIONS ON ALL SIDES IN CONTACT WITH CMU
 - B.** (2) MSTCM40 - LVL TO CMU

GIRDER TO GIRDER CONNECTION
FLANGE HANGER BY TRUSS ENGINEER.

THIS FRAMING PLAN IS DIAGRAMMATIC IN NATURE AND IS PROVIDED FOR ILLUSTRATION PURPOSES ONLY. TRUSS MANUFACTURER TO PROVIDE SEPARATE LAYOUT AND TRUSS COMPONENT DESIGN SIGNED AND SEALED BY A PROFESSIONAL ENGINEER AND REVIEWED BY P.E. OF RECORD.

**ALLEN ENGINEERING &
CONSTRUCTION SERVICES**
RICH ALLEN PROFESSIONAL ENGINEER
P.E. #56920 C.A. #9542
P.O. BOX 351
NEW PORT RICHEY, FL 34656
727-842-6100
richallenpe@gmail.com

I HEREBY CERTIFY THAT I HAVE PERFORMED THE ATTACHED DESIGN TO COMPLY WITH 145 MPH ULTIMATE WIND LOADS, EXPOSURE B AND IT IS IN COMPLIANCE WITH CHAPTER 16 OF THE 2010 FLORIDA BUILDING CODE. SEALED FOR THE STRUCTURE ONLY.

SIGNED
 RICHARD E. ALLEN P.E. #56920

LOT 9
PLANTATION

PLAN DATE

1. 04-02-2015
2. 04-07-2015
3. 04-10-2015
4. 04-15-2015
4. 09-14-2015


DEEB FAMILY
HOMES, LTD.
9400 RIVER CROSSING BLD.
NEW PORT RICHEY, FL. 34655

6A

A.E.C.S # 15031 LAUREL 3428


SCALE 1/8" = 1'-0"

TRUSS PLAN

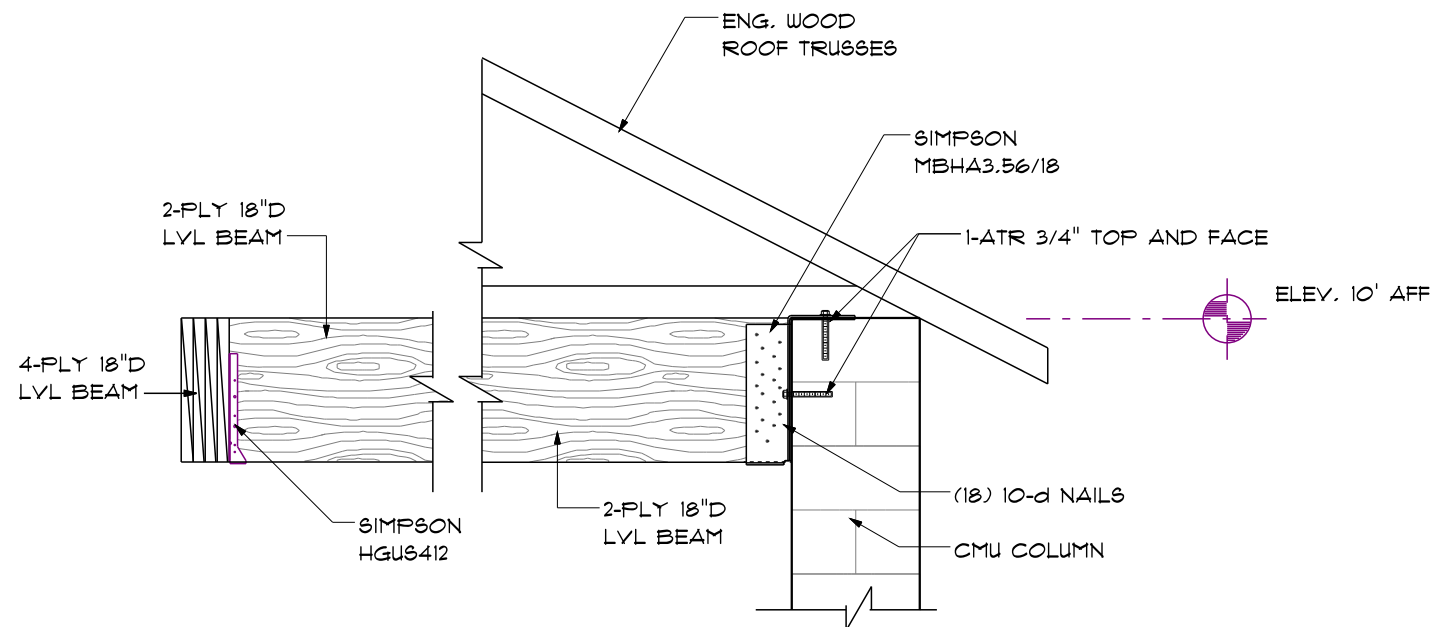

BEAM CONNECTION DETAIL 'AA'

SEE SHEET 6A FOR DETAIL LOCATIONS

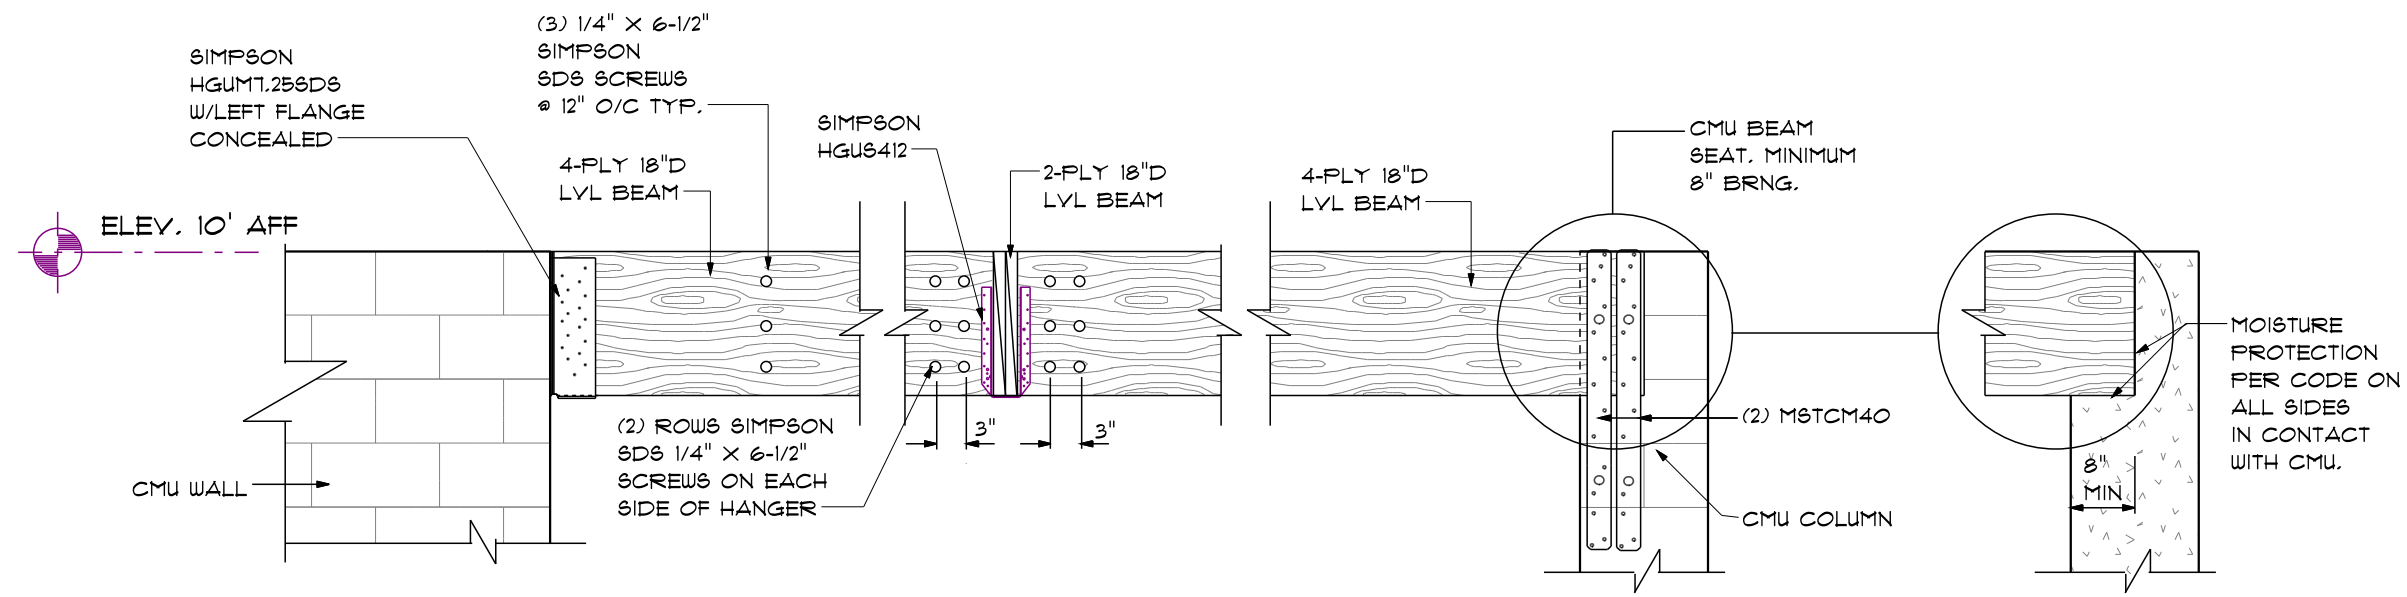

BEAM CONNECTION DETAIL 'BB'

LANAI BEAM DETAILS

SCALE 1/2" = 1'-0"

A.E.C.S # 15031 LAUREL 3428

DEEB FAMILY
HOMES, LTD.
9400 RIVER CROSSING BLD.
NEW PORT RICHEY, FL. 34655

6B

PLAN DATE


1.	04-02-2015
2.	04-07-2015
3.	04-10-2015
4.	04-15-2015
5.	09-14-2015

LOT 9
PLANTATION

I HEREBY CERTIFY THAT I HAVE
PERFORMED THE ATTACHED DESIGN
TO COMPLY WITH 145 MPH ULTIMATE
WIND LOADS, EXPOSURE B AND IT IS
IN COMPLIANCE WITH CHAPTER 16 OF
THE 2010 FLORIDA BUILDING CODE.
SEALED FOR THE STRUCTURE ONLY.

SIGNED
RICHARD E. ALLEN P.E. #56920

ALLEN ENGINEERING &
CONSTRUCTION SERVICES
RICH ALLEN PROFESSIONAL ENGINEER
P.E. #56920 C.A. #9542
P.O. BOX 351
NEW PORT RICHEY, FL 34656
727-842-6100
richallenpe@gmail.com

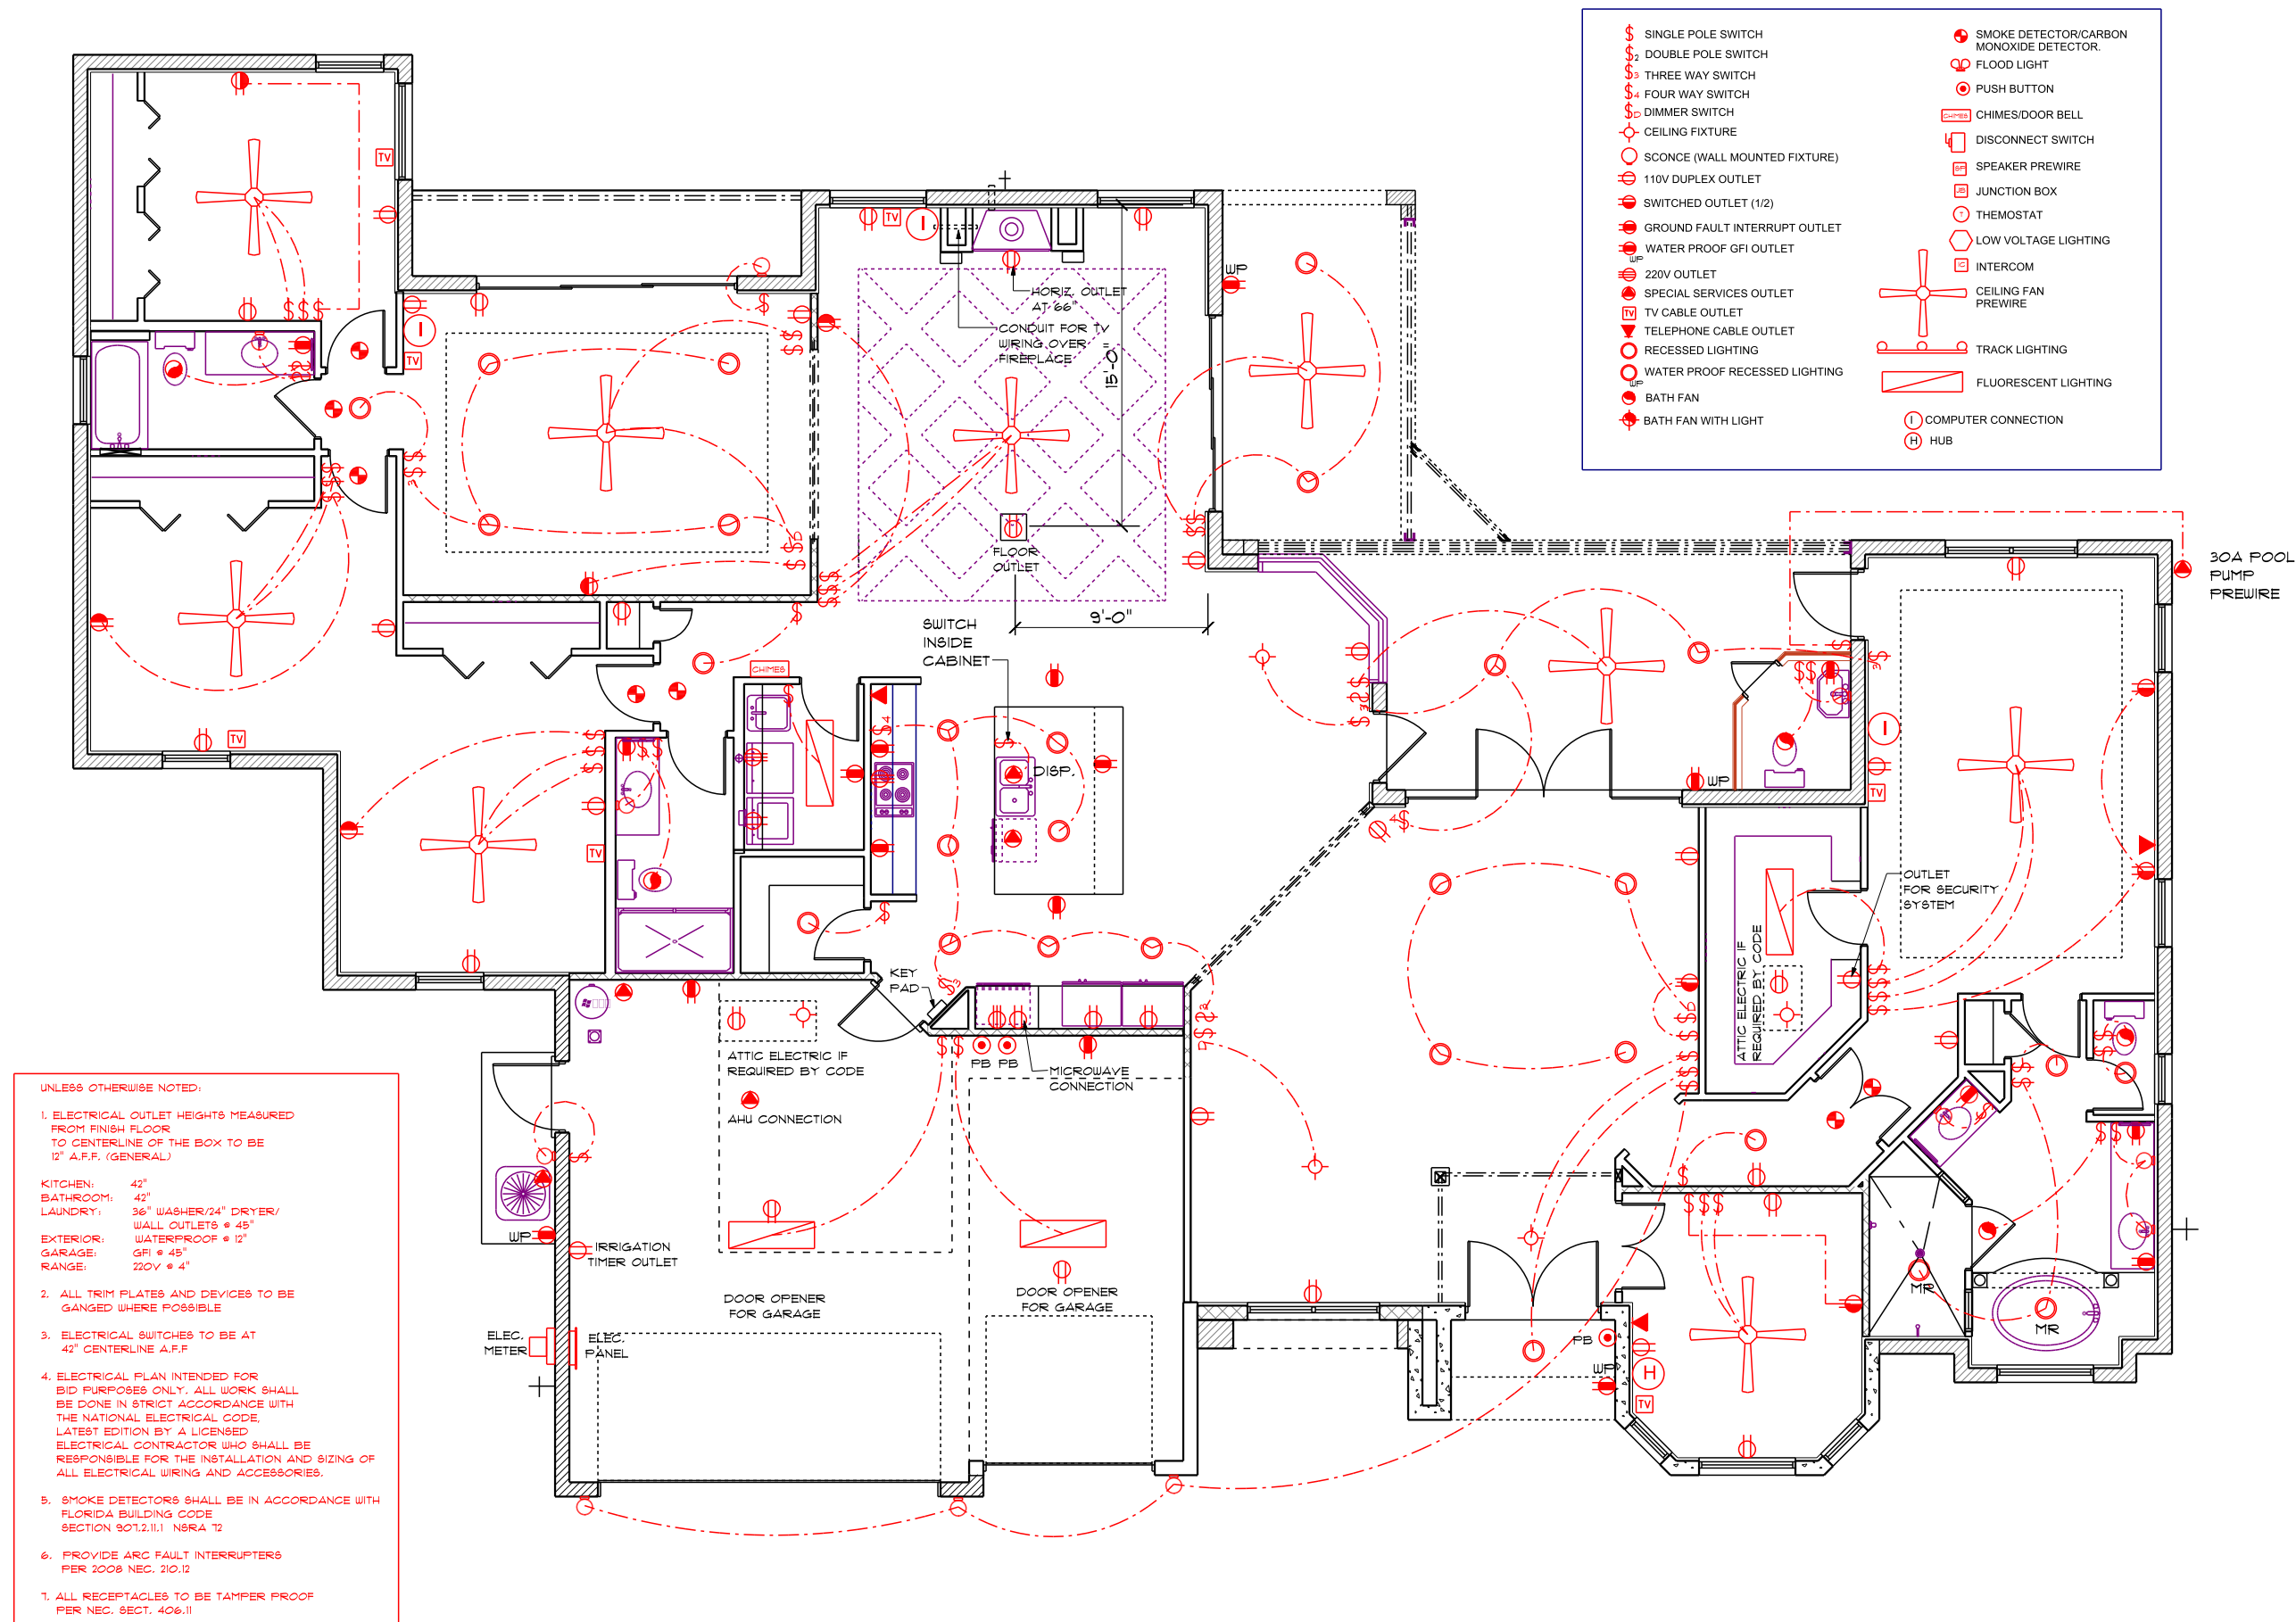

ELECTRICAL PLAN

LAUREL 3428

LOT 9
PLANTATION

